



Henningson, Durham
& Richardson, Inc.
and
Harvey G. Moore
Architects




COLLIN COUNTY
JUSTICE
CENTER
DETENTION FACILITY
SHERIFFS
ADMINISTRATION
BUILDING
CENTRAL POWER
PLANT


SECOND LEVEL
AREA H
FLOOR PLAN
PLUMBING &
FIRE PROTECTION

FOR BIDDING AND
CONSTRUCTION



Project Number	06761-002-032
Date	MARCH 9, 1992
Project Manager	OLSON
Design	PRICE
Structural	SHOLL
Mechanical	GILL
Electrical	HYMAN
Site	ELLWOOD
Drawn By	MECH TECH
Scale	1/8"=1'-0"
Revisions	RFI #242, 574

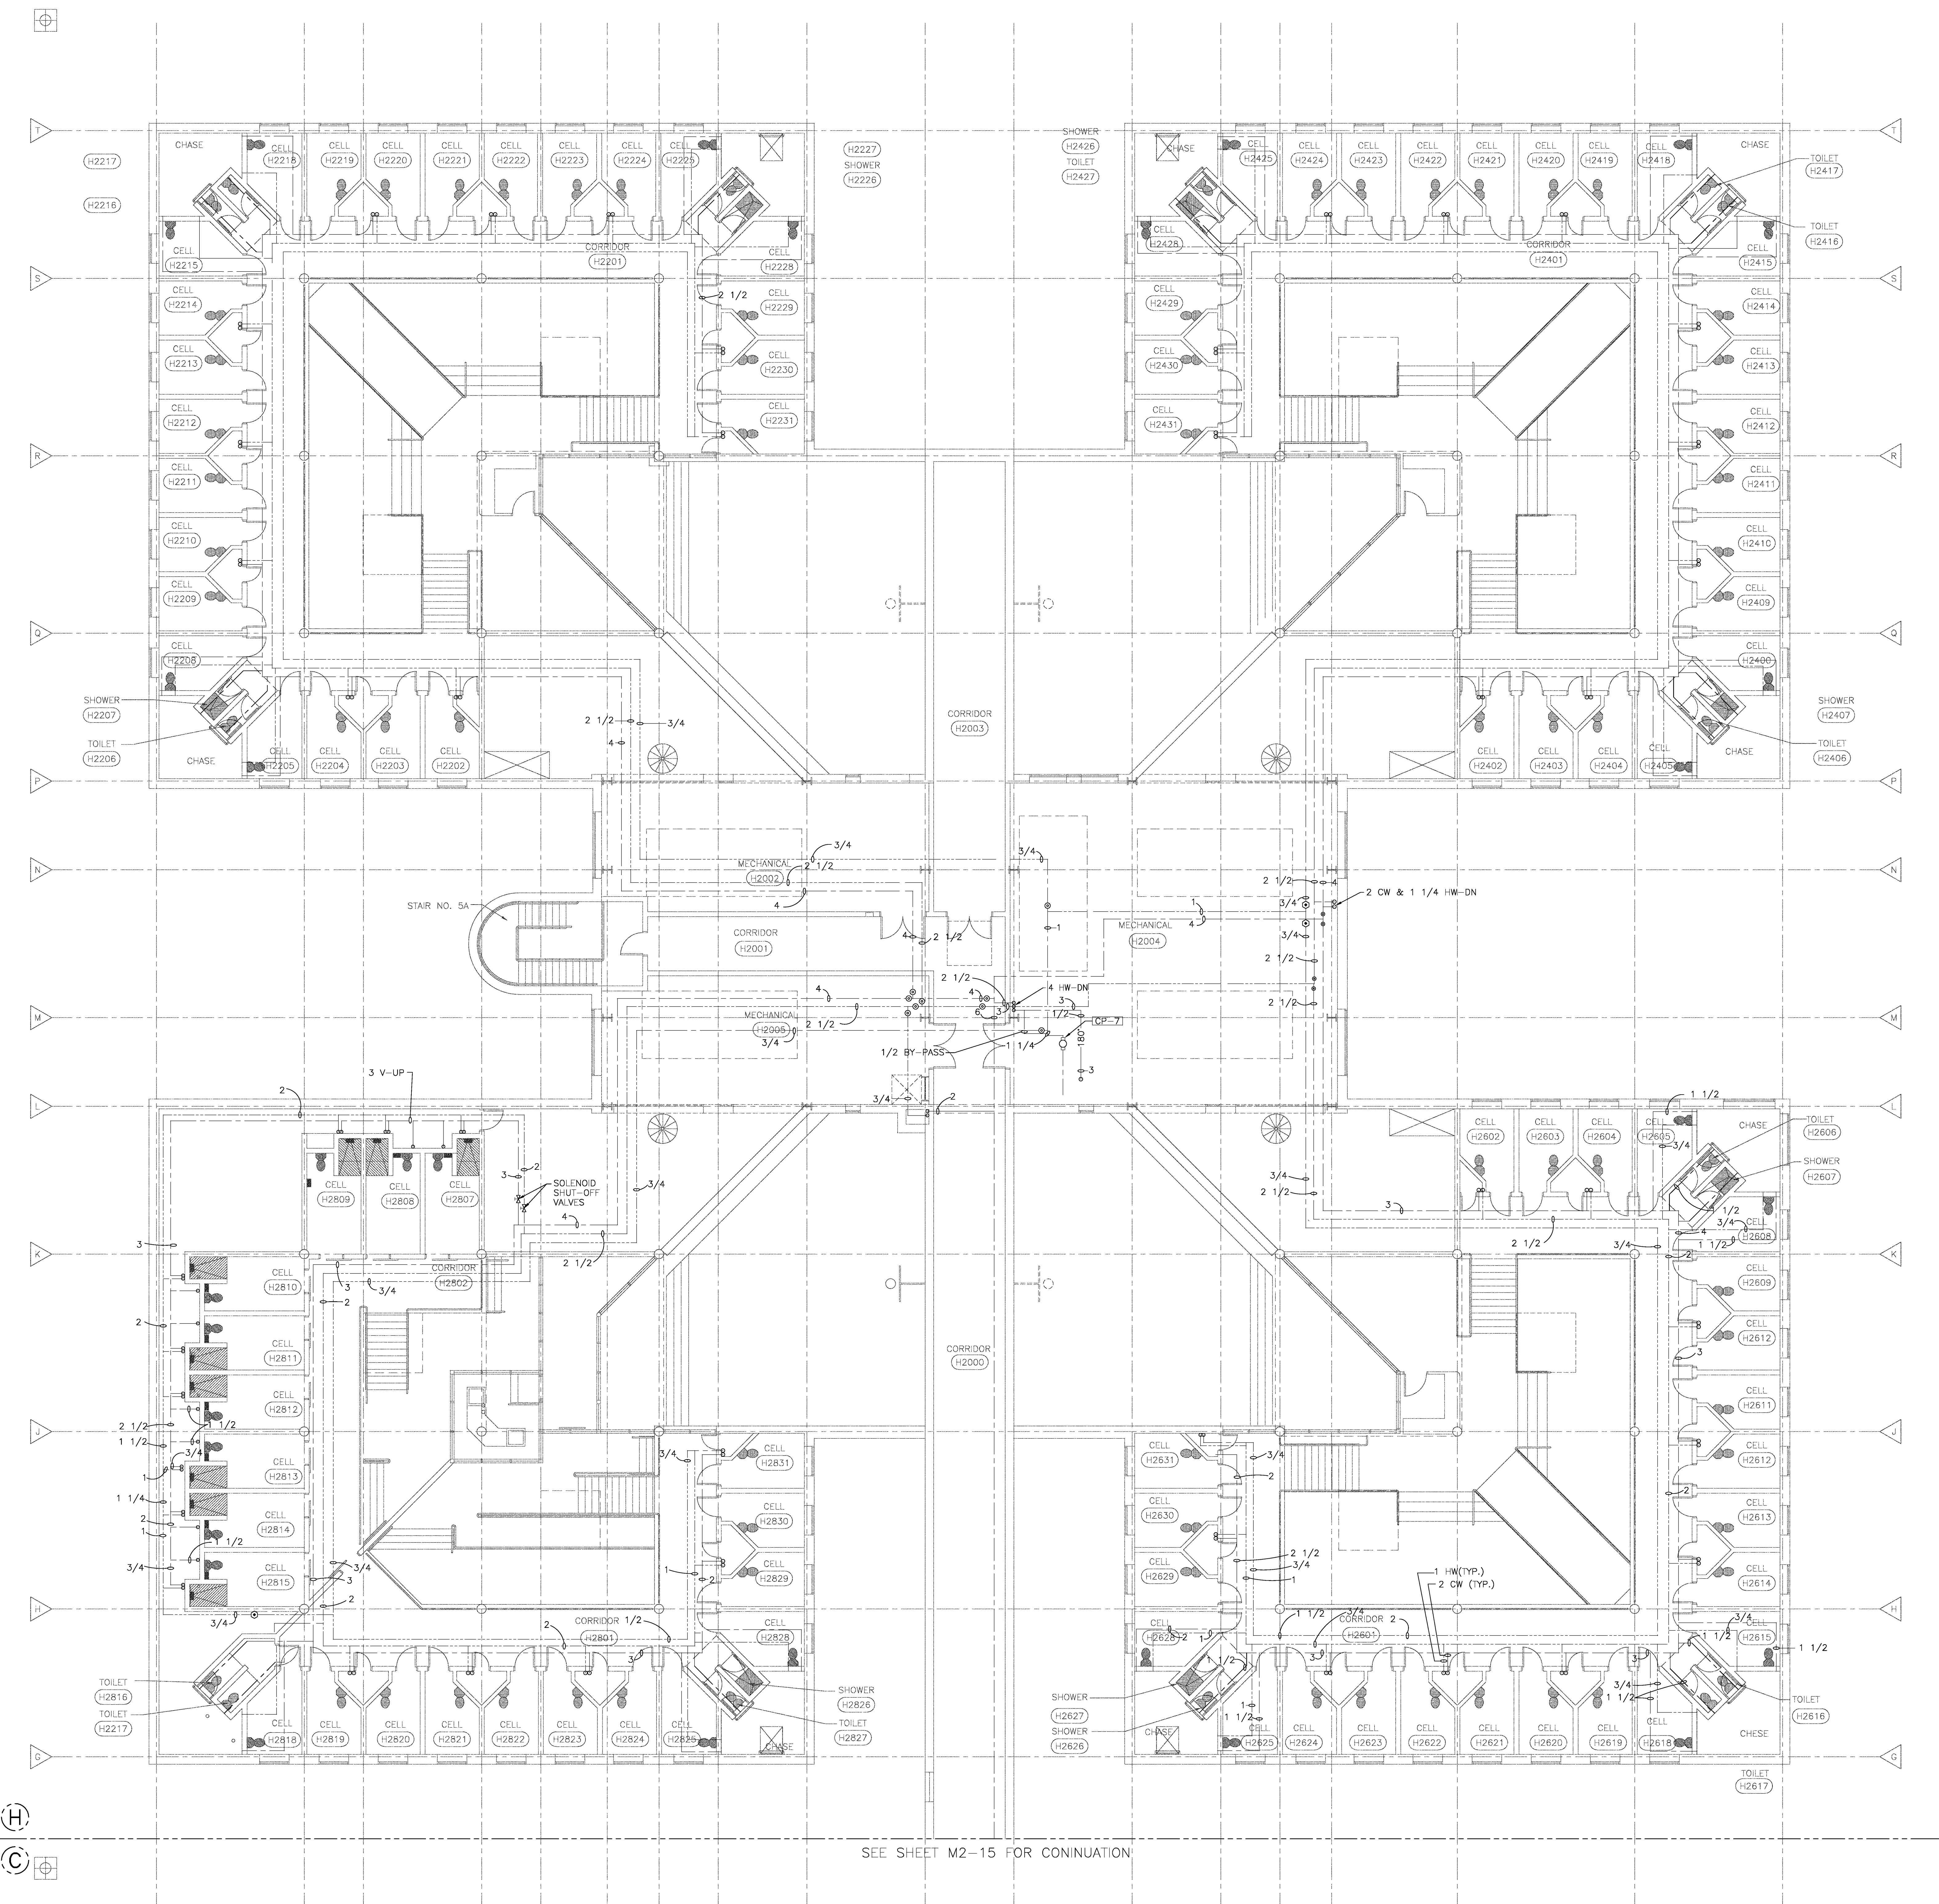


SEE SHEET M2-15 FOR CONINUATION

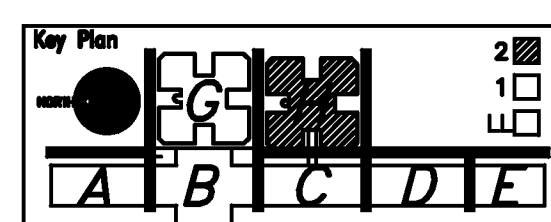

Sheet Number
M2-19

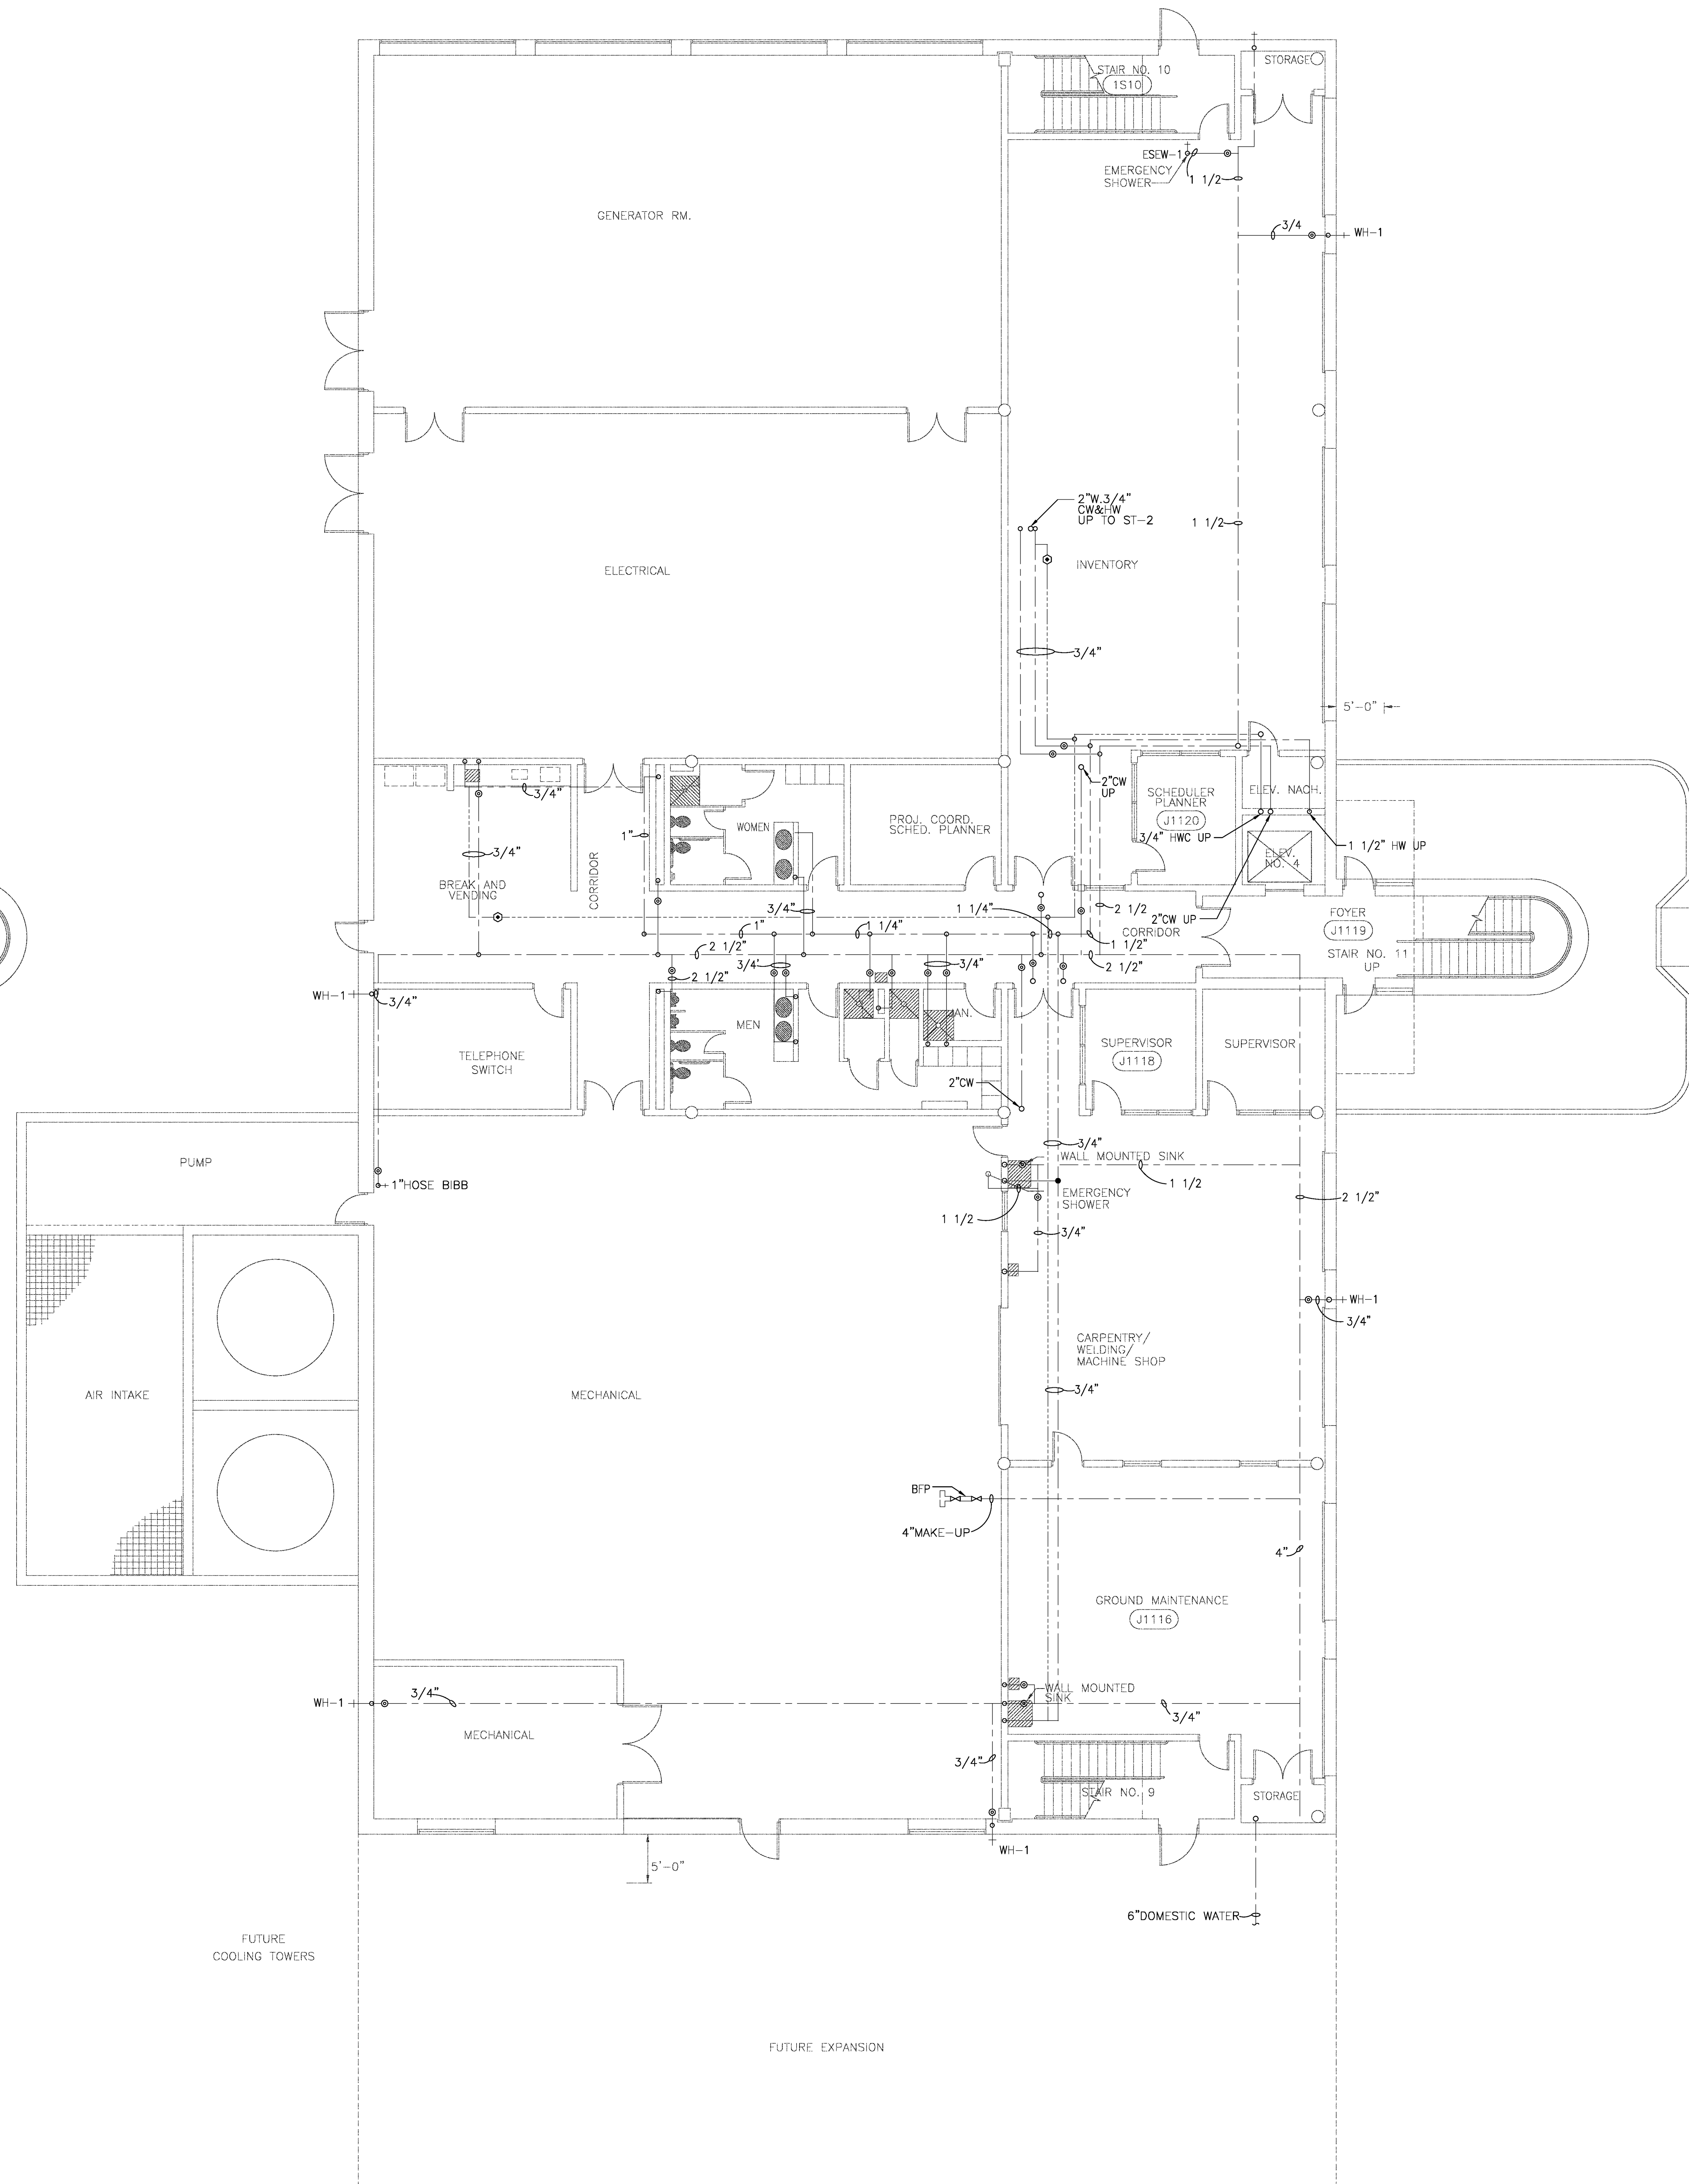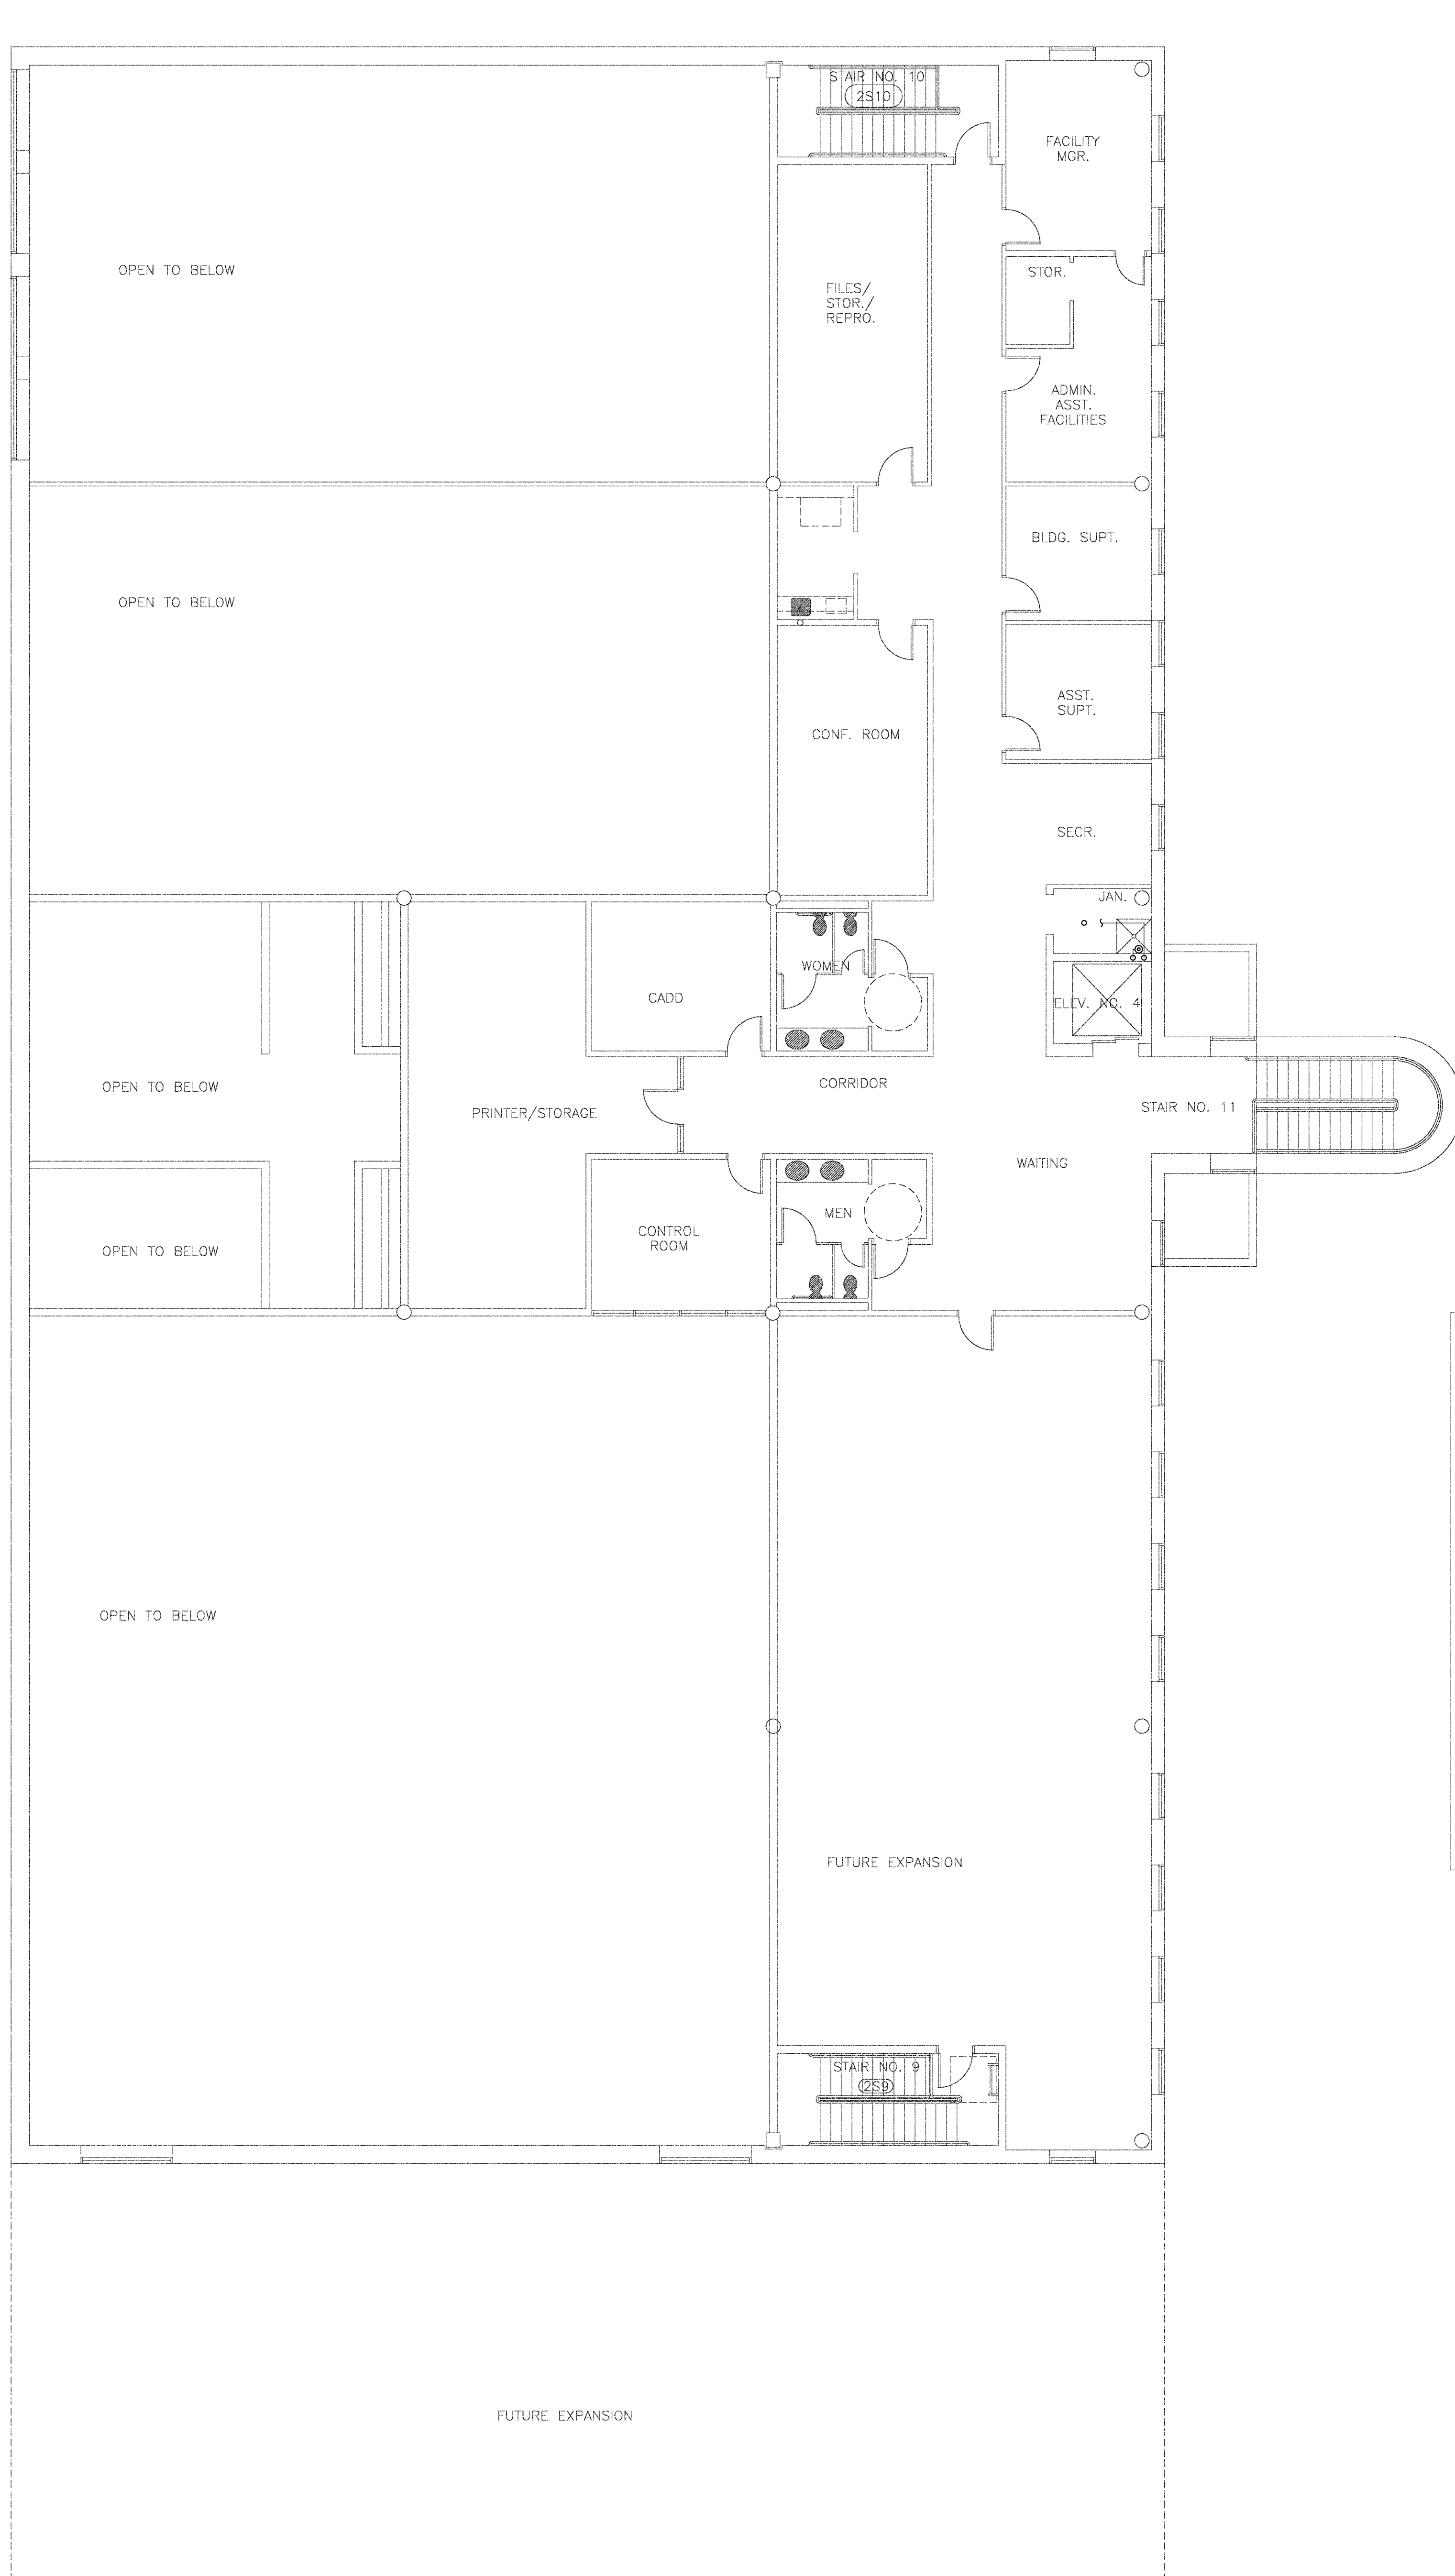

Henningson, Durham
& Richardson, Inc.
and
Harvey G. Moore
Architects

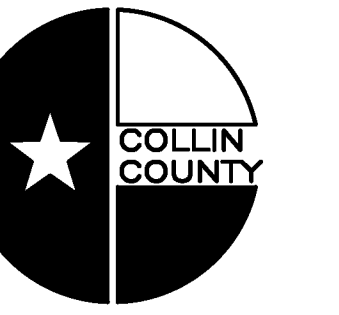


COLLIN COUNTY
JUSTICE
CENTER
DETENTION FACILITY
SHERIFFS
ADMINISTRATION
BUILDING
CENTRAL POWER
PLANT

CENTRAL PLANT
AREA J
PLUMBING &
FIRE PROTECTION

FOR BIDDING AND
CONSTRUCTION

Project Number	06761-002-032
Date	MARCH 9, 1992
Project Manager	OLSON
Design	PRICE
Structural	SHOLL
Mechanical	GILL
Electrical	HYMAN
Site	ELLWOOD
Drawn By	MECH TECH
Scale	1/8"=1'-0"
Revisions	AD-2


Sheet Number
M2-20

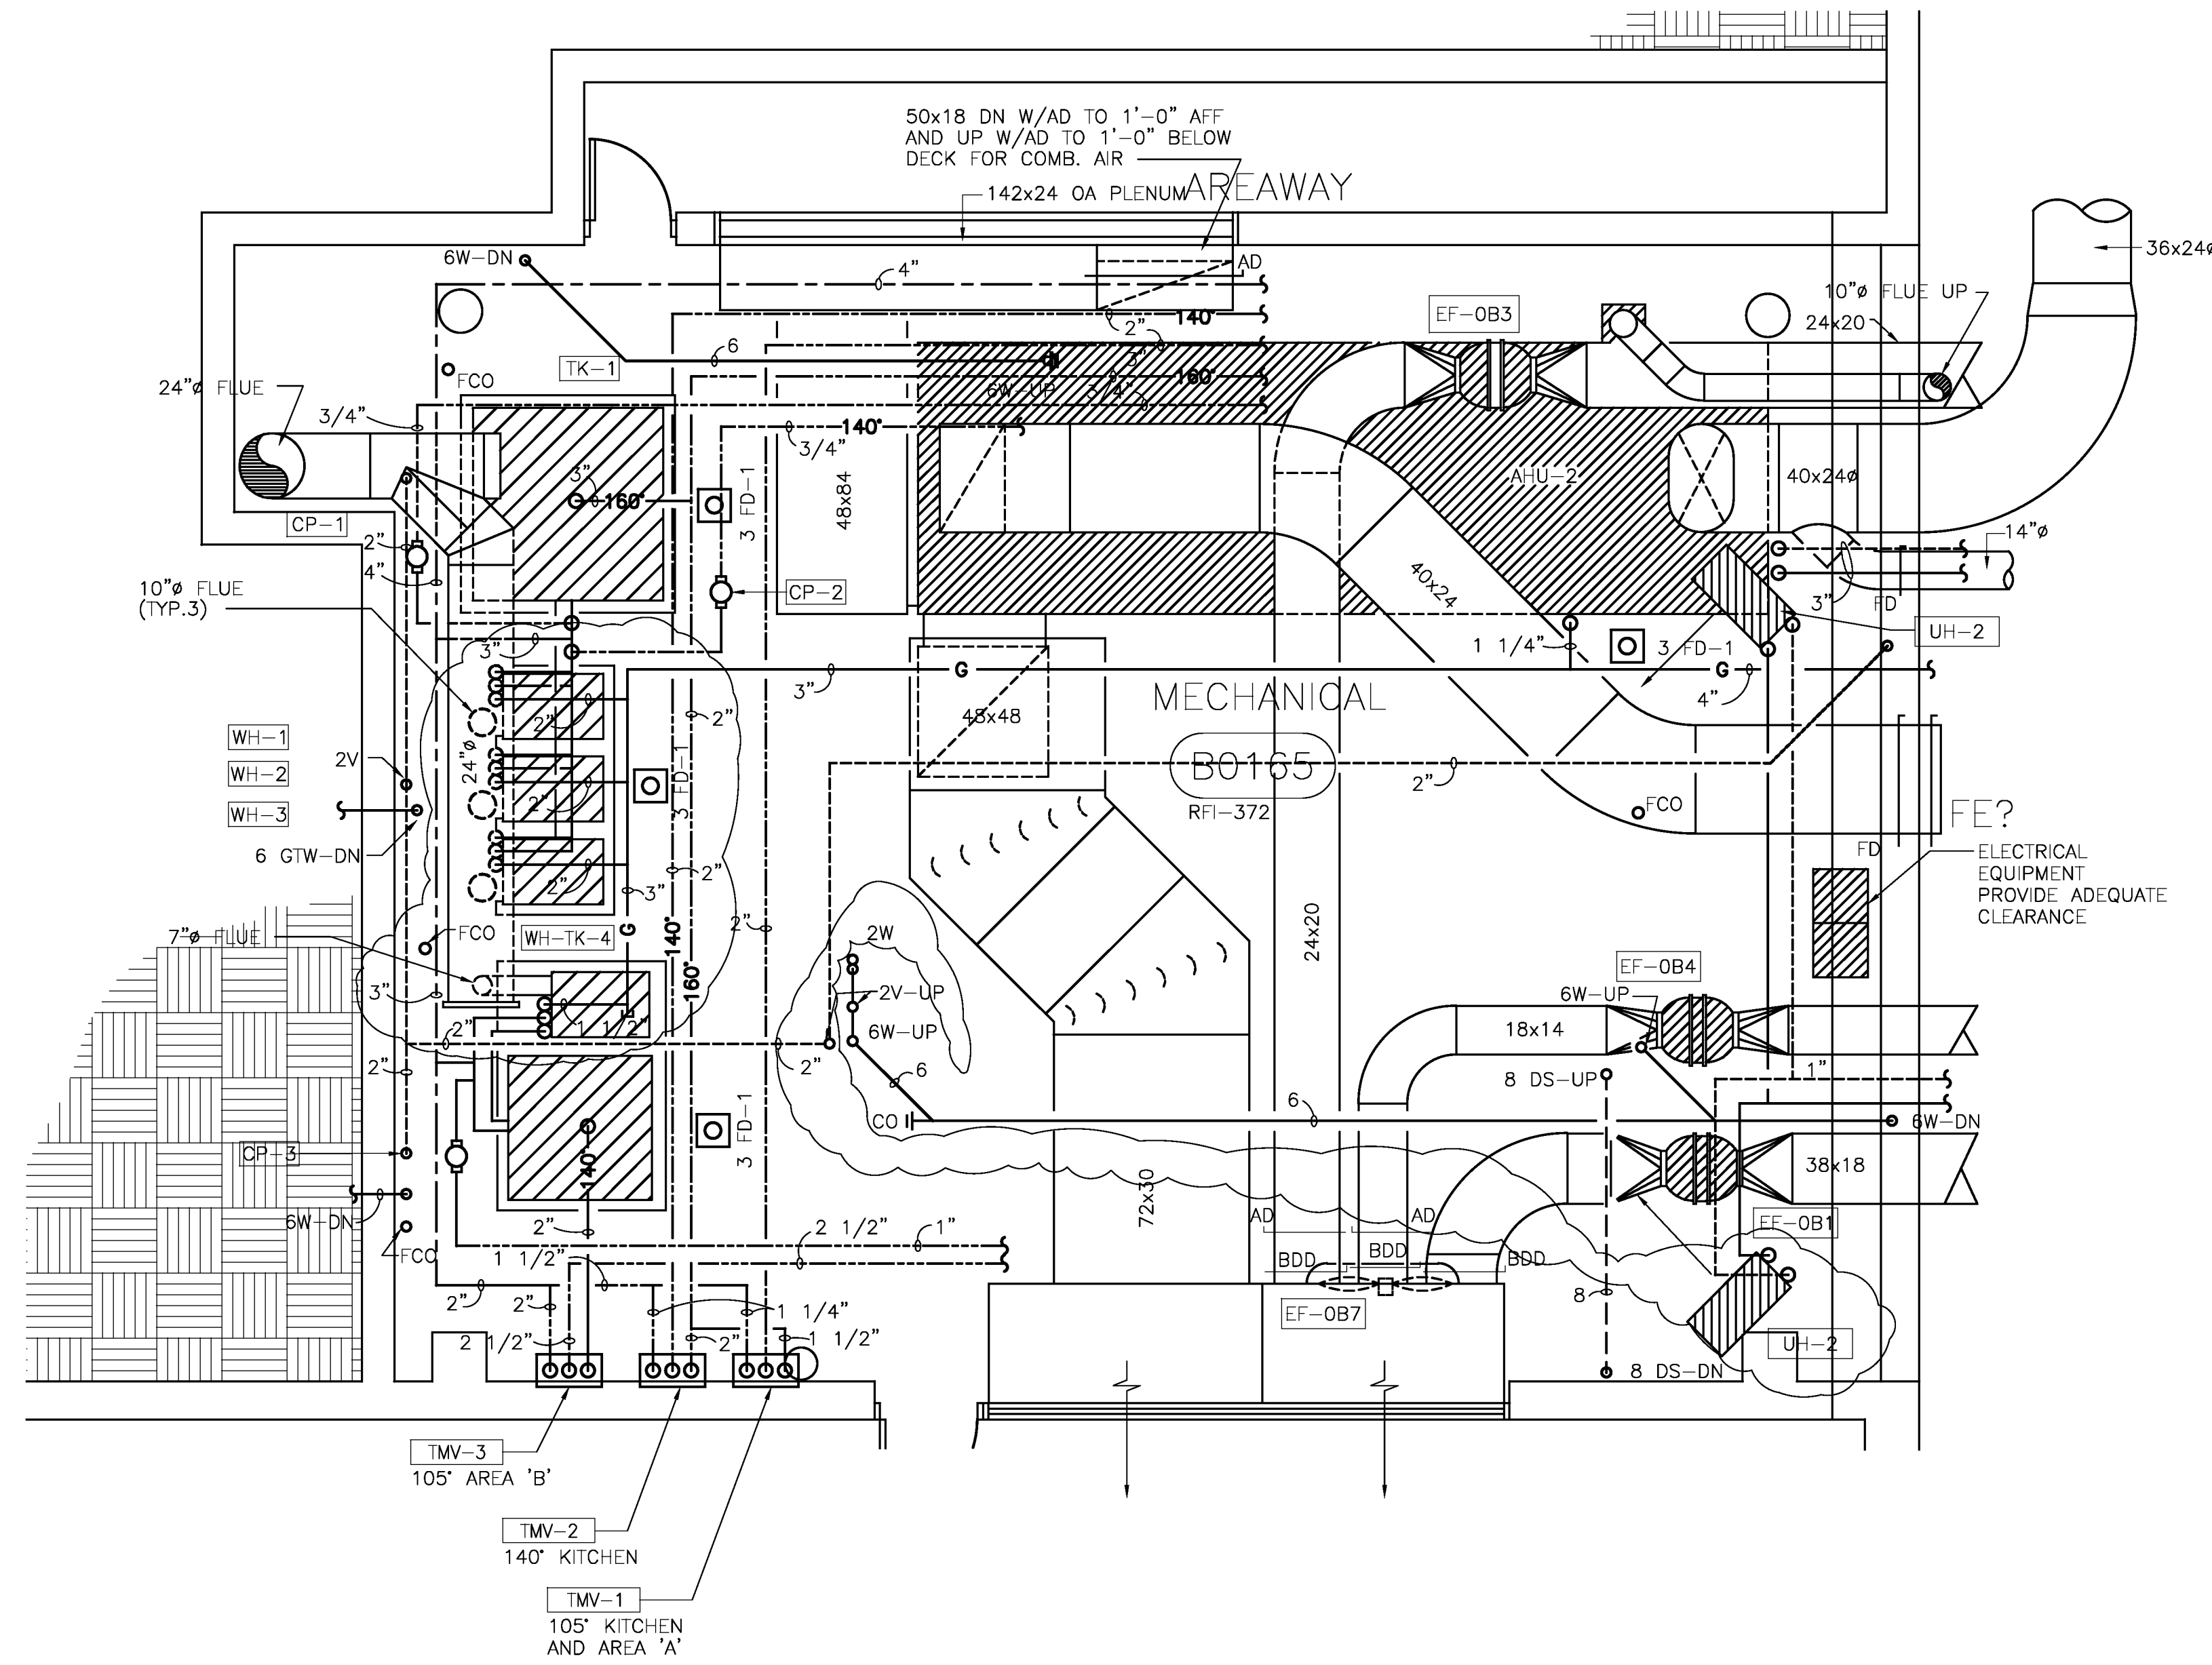

LOWER LEVEL MECHANICAL ROOM

SCALE: 1/4"=1'-0"

1
M5-2

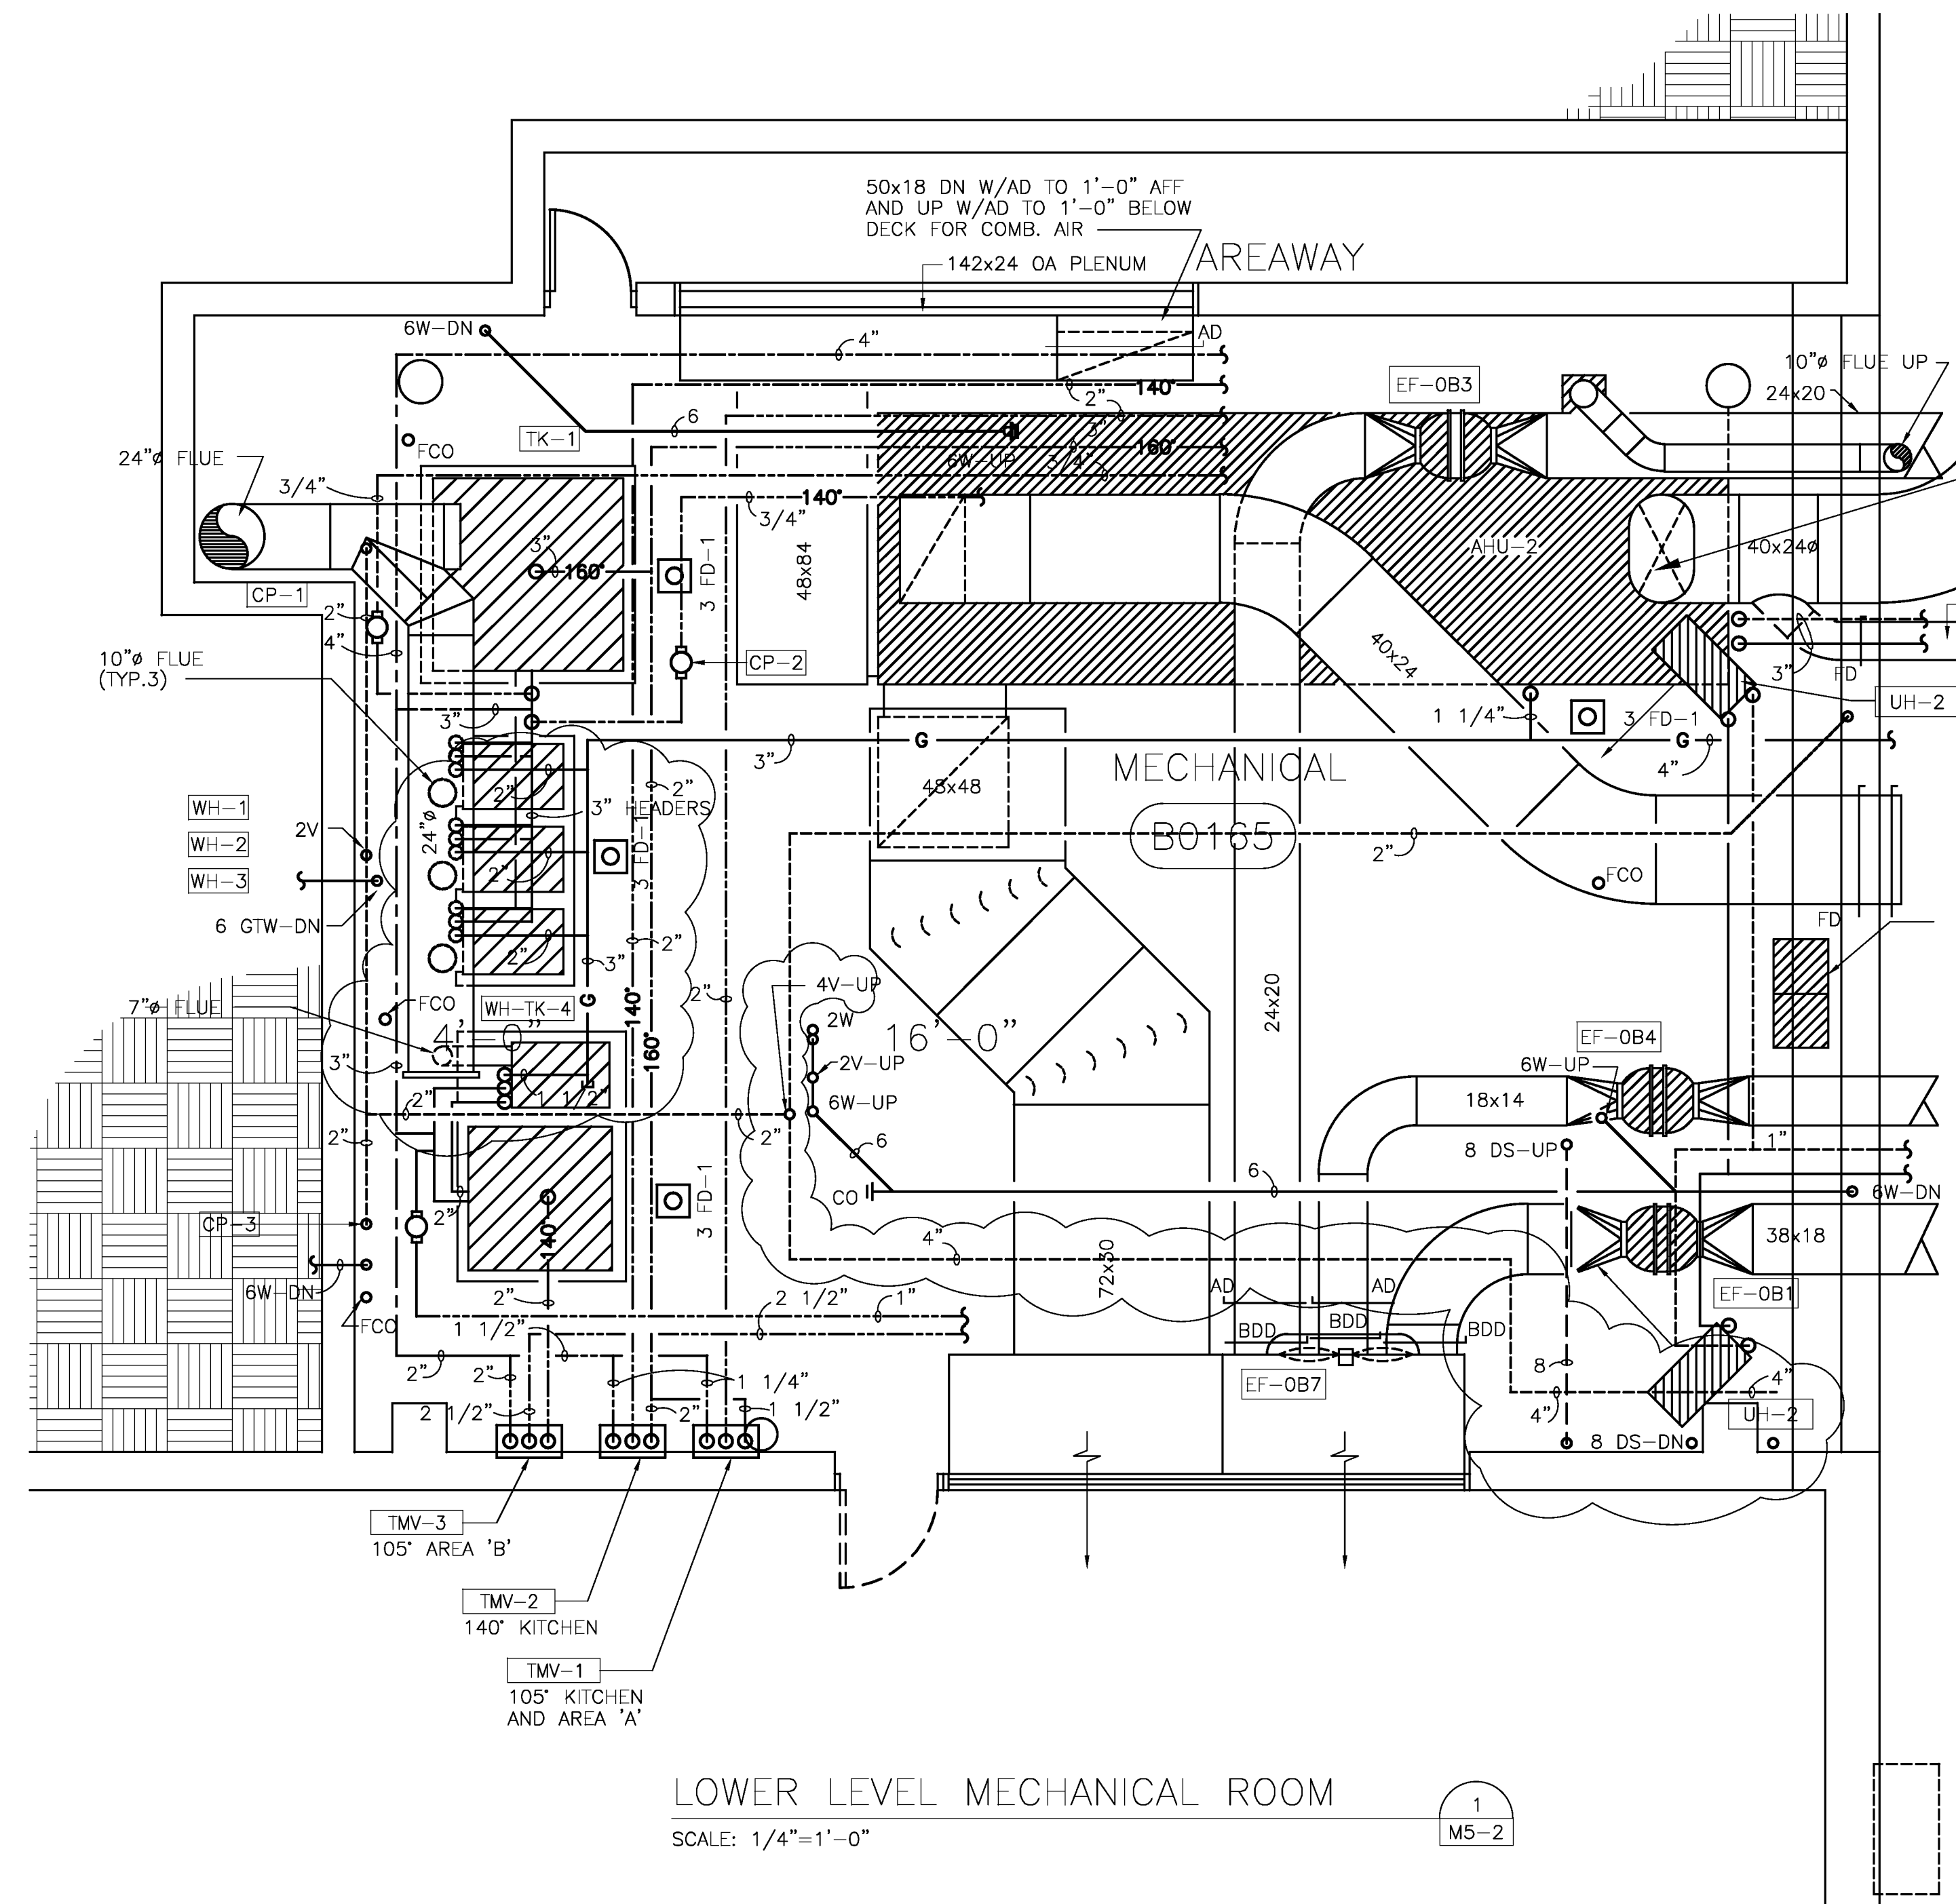

LOWER LEVEL MECHANICAL ROOM

SCALE: 1/4"=1'-0"

1
M5-2

XX RFI #428
XXX AHU Will be a
(6) 2'X2'X5 1/4"
Concrete
Pads



Henningson, Durham
& Richardson, Inc.

and
Harvey G. Moore
Architects



COLLIN COUNTY
JUSTICE
CENTER

DETENTION FACILITY
SHERIFFS
ADMINISTRATION
BUILDING
CENTRAL POWER
PLANT

ENLARGED
AIR HANDLING
ROOMS
—MECHANICAL

FOR BIDDING AND
CONSTRUCTION

Project Number	06761-002-032
Date	MARCH 9, 1992
Project Manager	OLSON
Design	PRICE
Structural	SHOLL
Mechanical	GILL
Electrical	HYMAN
Site	ELLWOOD
Drawn By	MECH TECH
Scale	1/4"=1'-0"


Revisions
AD-2
RFI-372, 428

Sheet Number


M5-2

M5-16

File Name: \\27000A\27183\CADD\PI-01-PL-27183.dwg
Current Tab (Layout) : PI-01 User: AH2262
Printed Date: 1/22/2010 2:56:08 PM

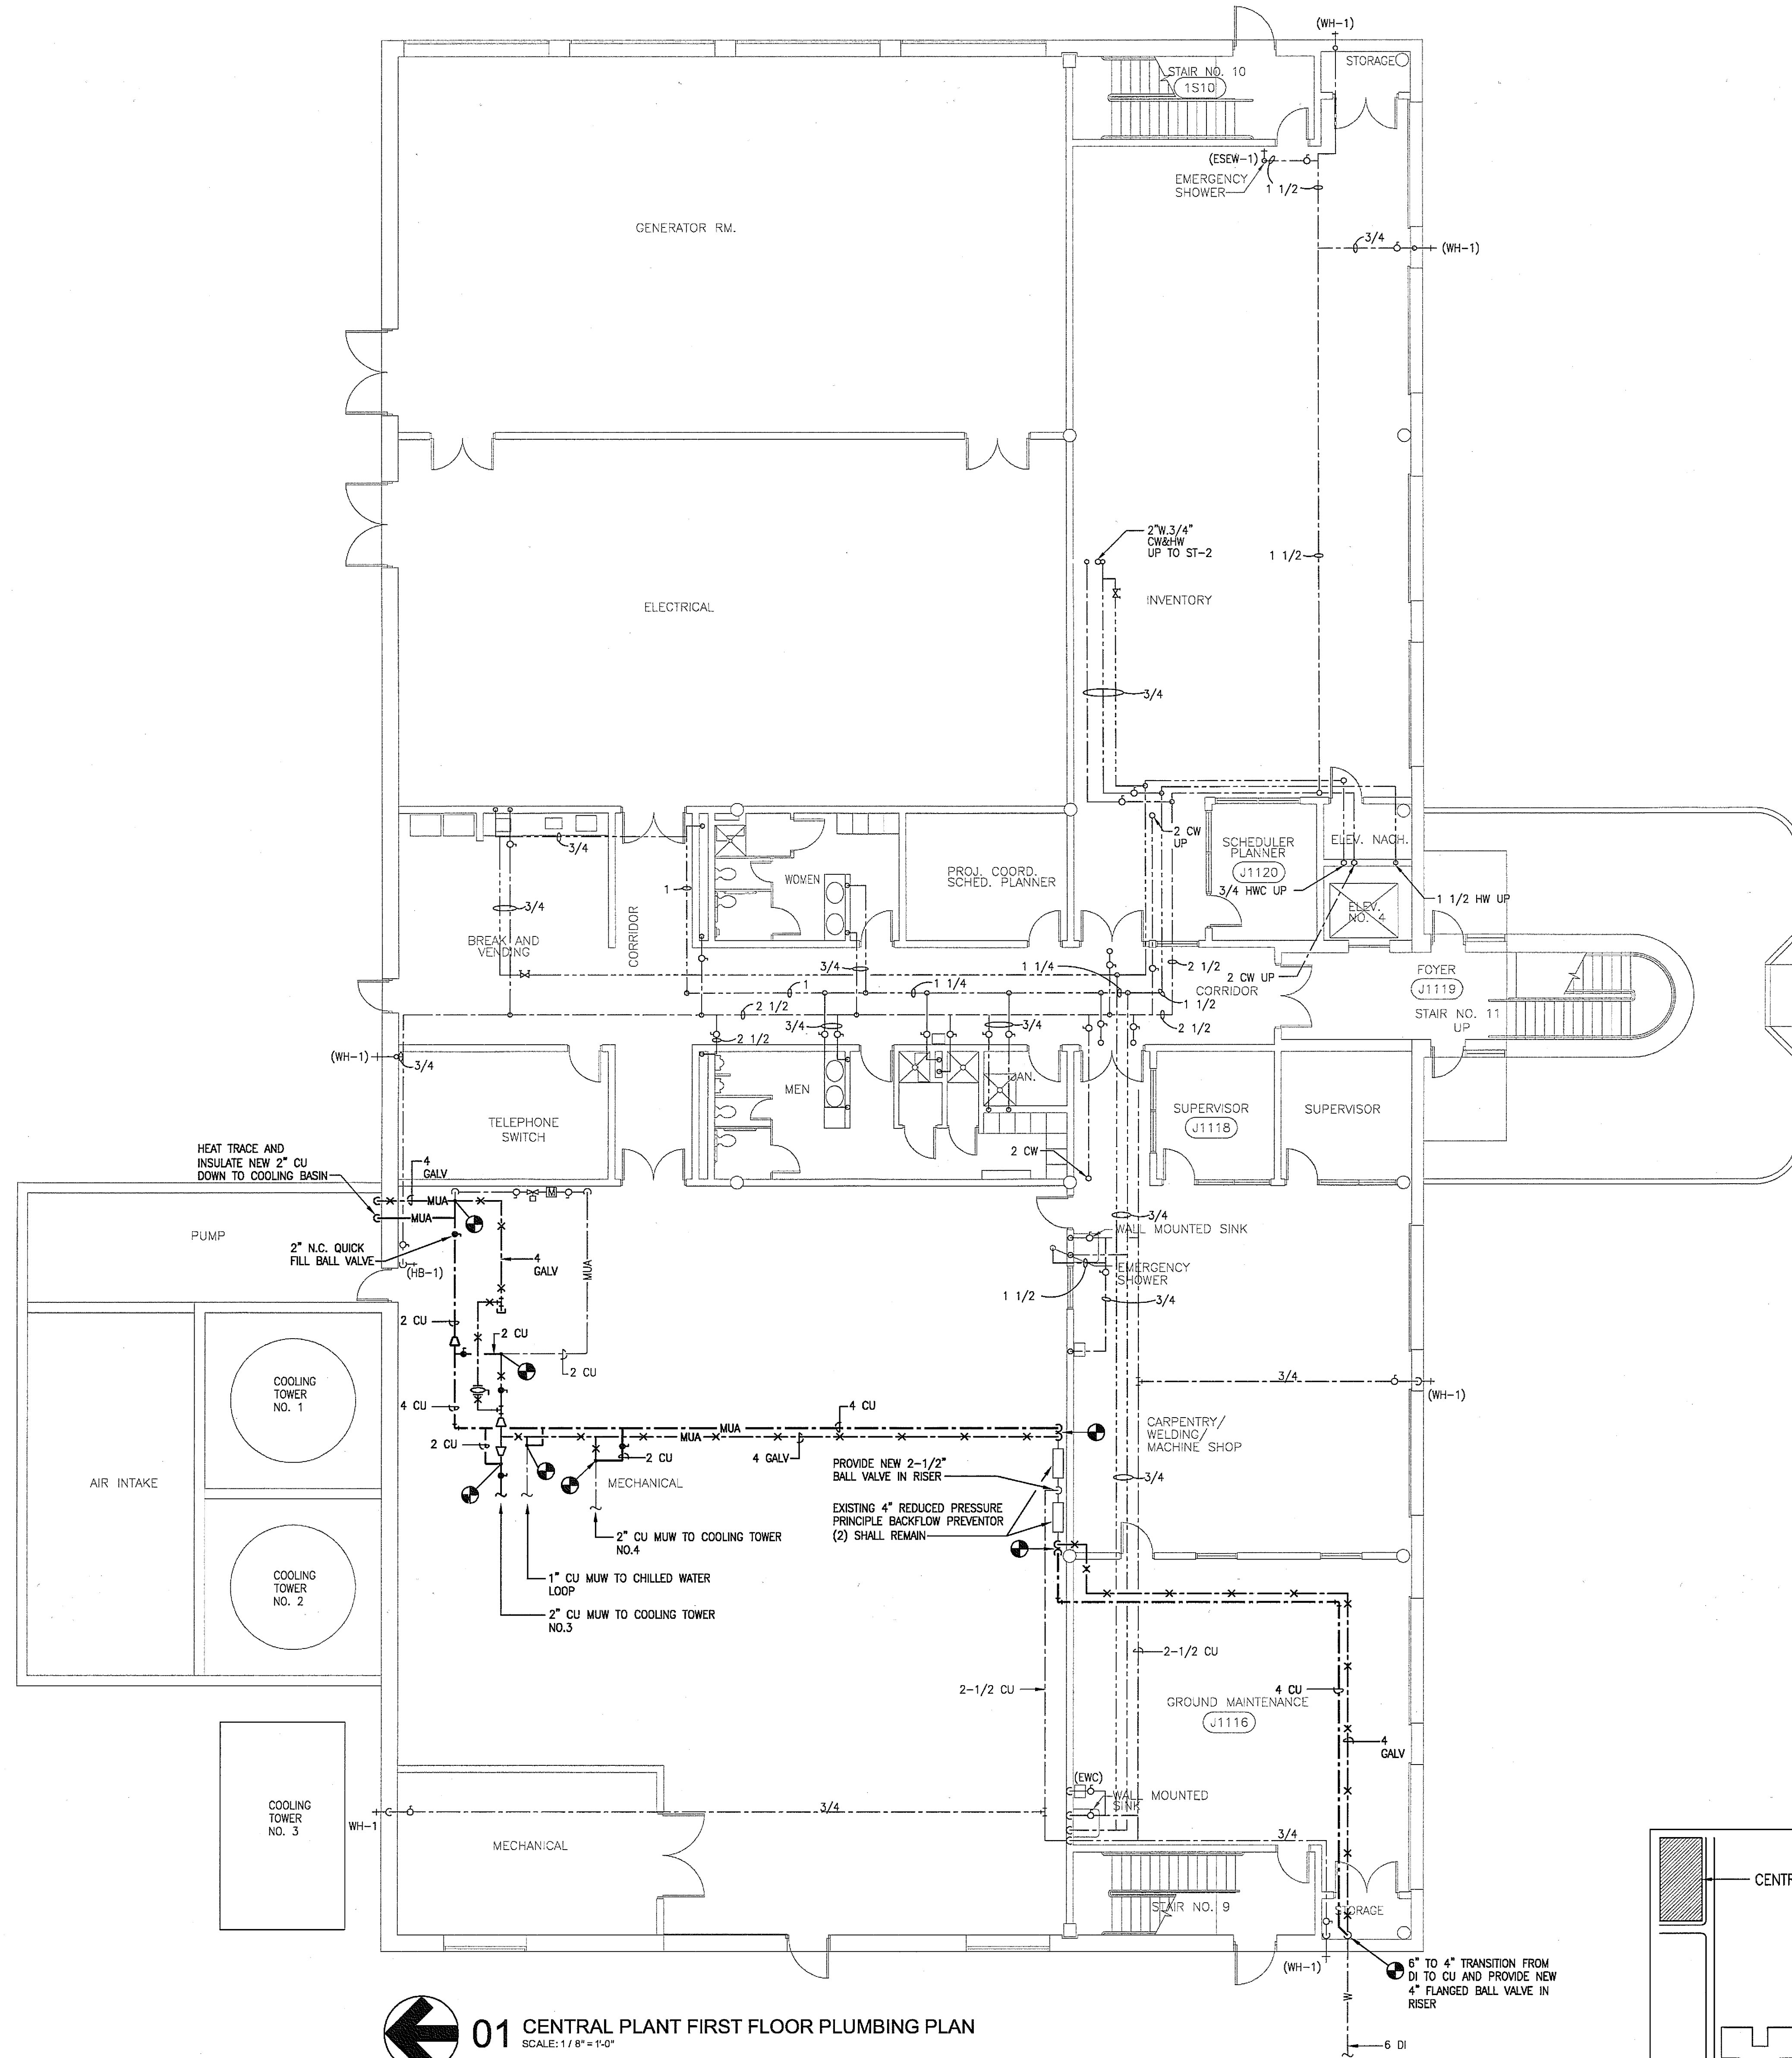

01 CENTRAL PLANT FIRST FLOOR PLUMBING PLAN
SCALE: 1/8" = 1'-0"

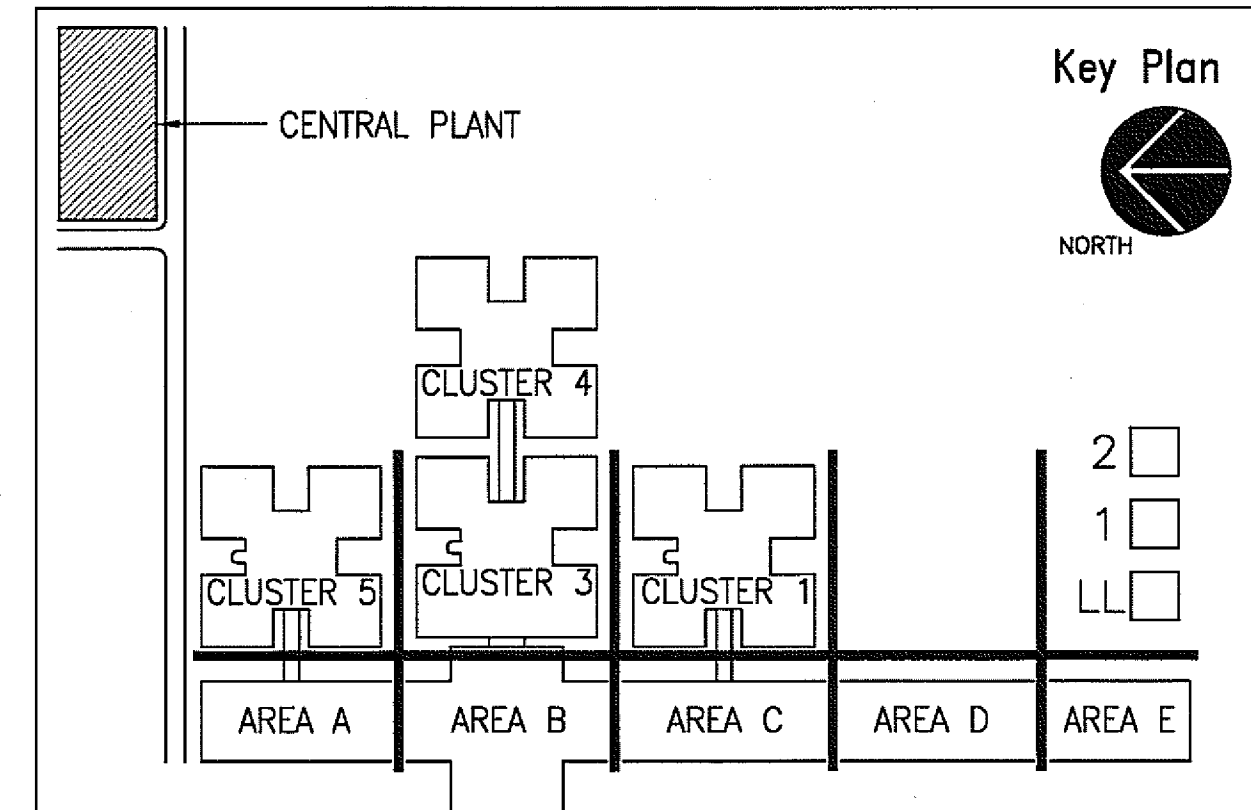

Key Plan

2
1
LL

CLUSTER 4
CLUSTER 3
CLUSTER 2
CLUSTER 1

AREA A AREA B AREA C AREA D AREA E

Project No.: 27183
Issued: 07/21/2010
Drawn By: BO
Checked By: CW
Scale: AS NOTED
Sheet Title:
CENTRAL PLANT
FIRST FLOOR
PLUMBING PLAN
P1-01
Sheet Number


HALFF
1201 N. BOWSER ROAD
RICHARDSON, TEXAS 75081
TEL (972) 344-8000
FAX (972) 344-8001
TDD (972) 344-8002
TDD (972) 344-8003
TDD (972) 344-8004
TDD (972) 344-8005
TDD (972) 344-8006
TDD (972) 344-8007
TDD (972) 344-8008
TDD (972) 344-8009
TDD (972) 344-8010

JUSTICE CENTER DOMESTIC WATER LINE REPLACEMENT
McKinney, Texas


COLLIN COUNTY

THE SEAL APPEARING ON THIS DOCUMENT WAS AUTHORIZED BY CHANDLER WOODS, P.E. 81586 ON 07/21/10. ALTERATION OF A SEALED DOCUMENT WITHOUT PROPER NOTIFICATION TO THE RESPONSIBLE ENGINEER IS AN OFFENSE UNDER THE TEXAS ENGINEERING PRACTICE ACT. THE RECORD COPY OF THIS DRAWING IS ON FILE AT THE OFFICES OF HALFF, 1201 N. BOWSER ROAD, RICHARDSON, TEXAS 75081


File Name: I:\27000a\27183\CADD\P102-PL-27183.dwg
Current Tab (Layout) : P1-02 User: AP#519
Printed Date: 1/22/2010 2:56:08 PM

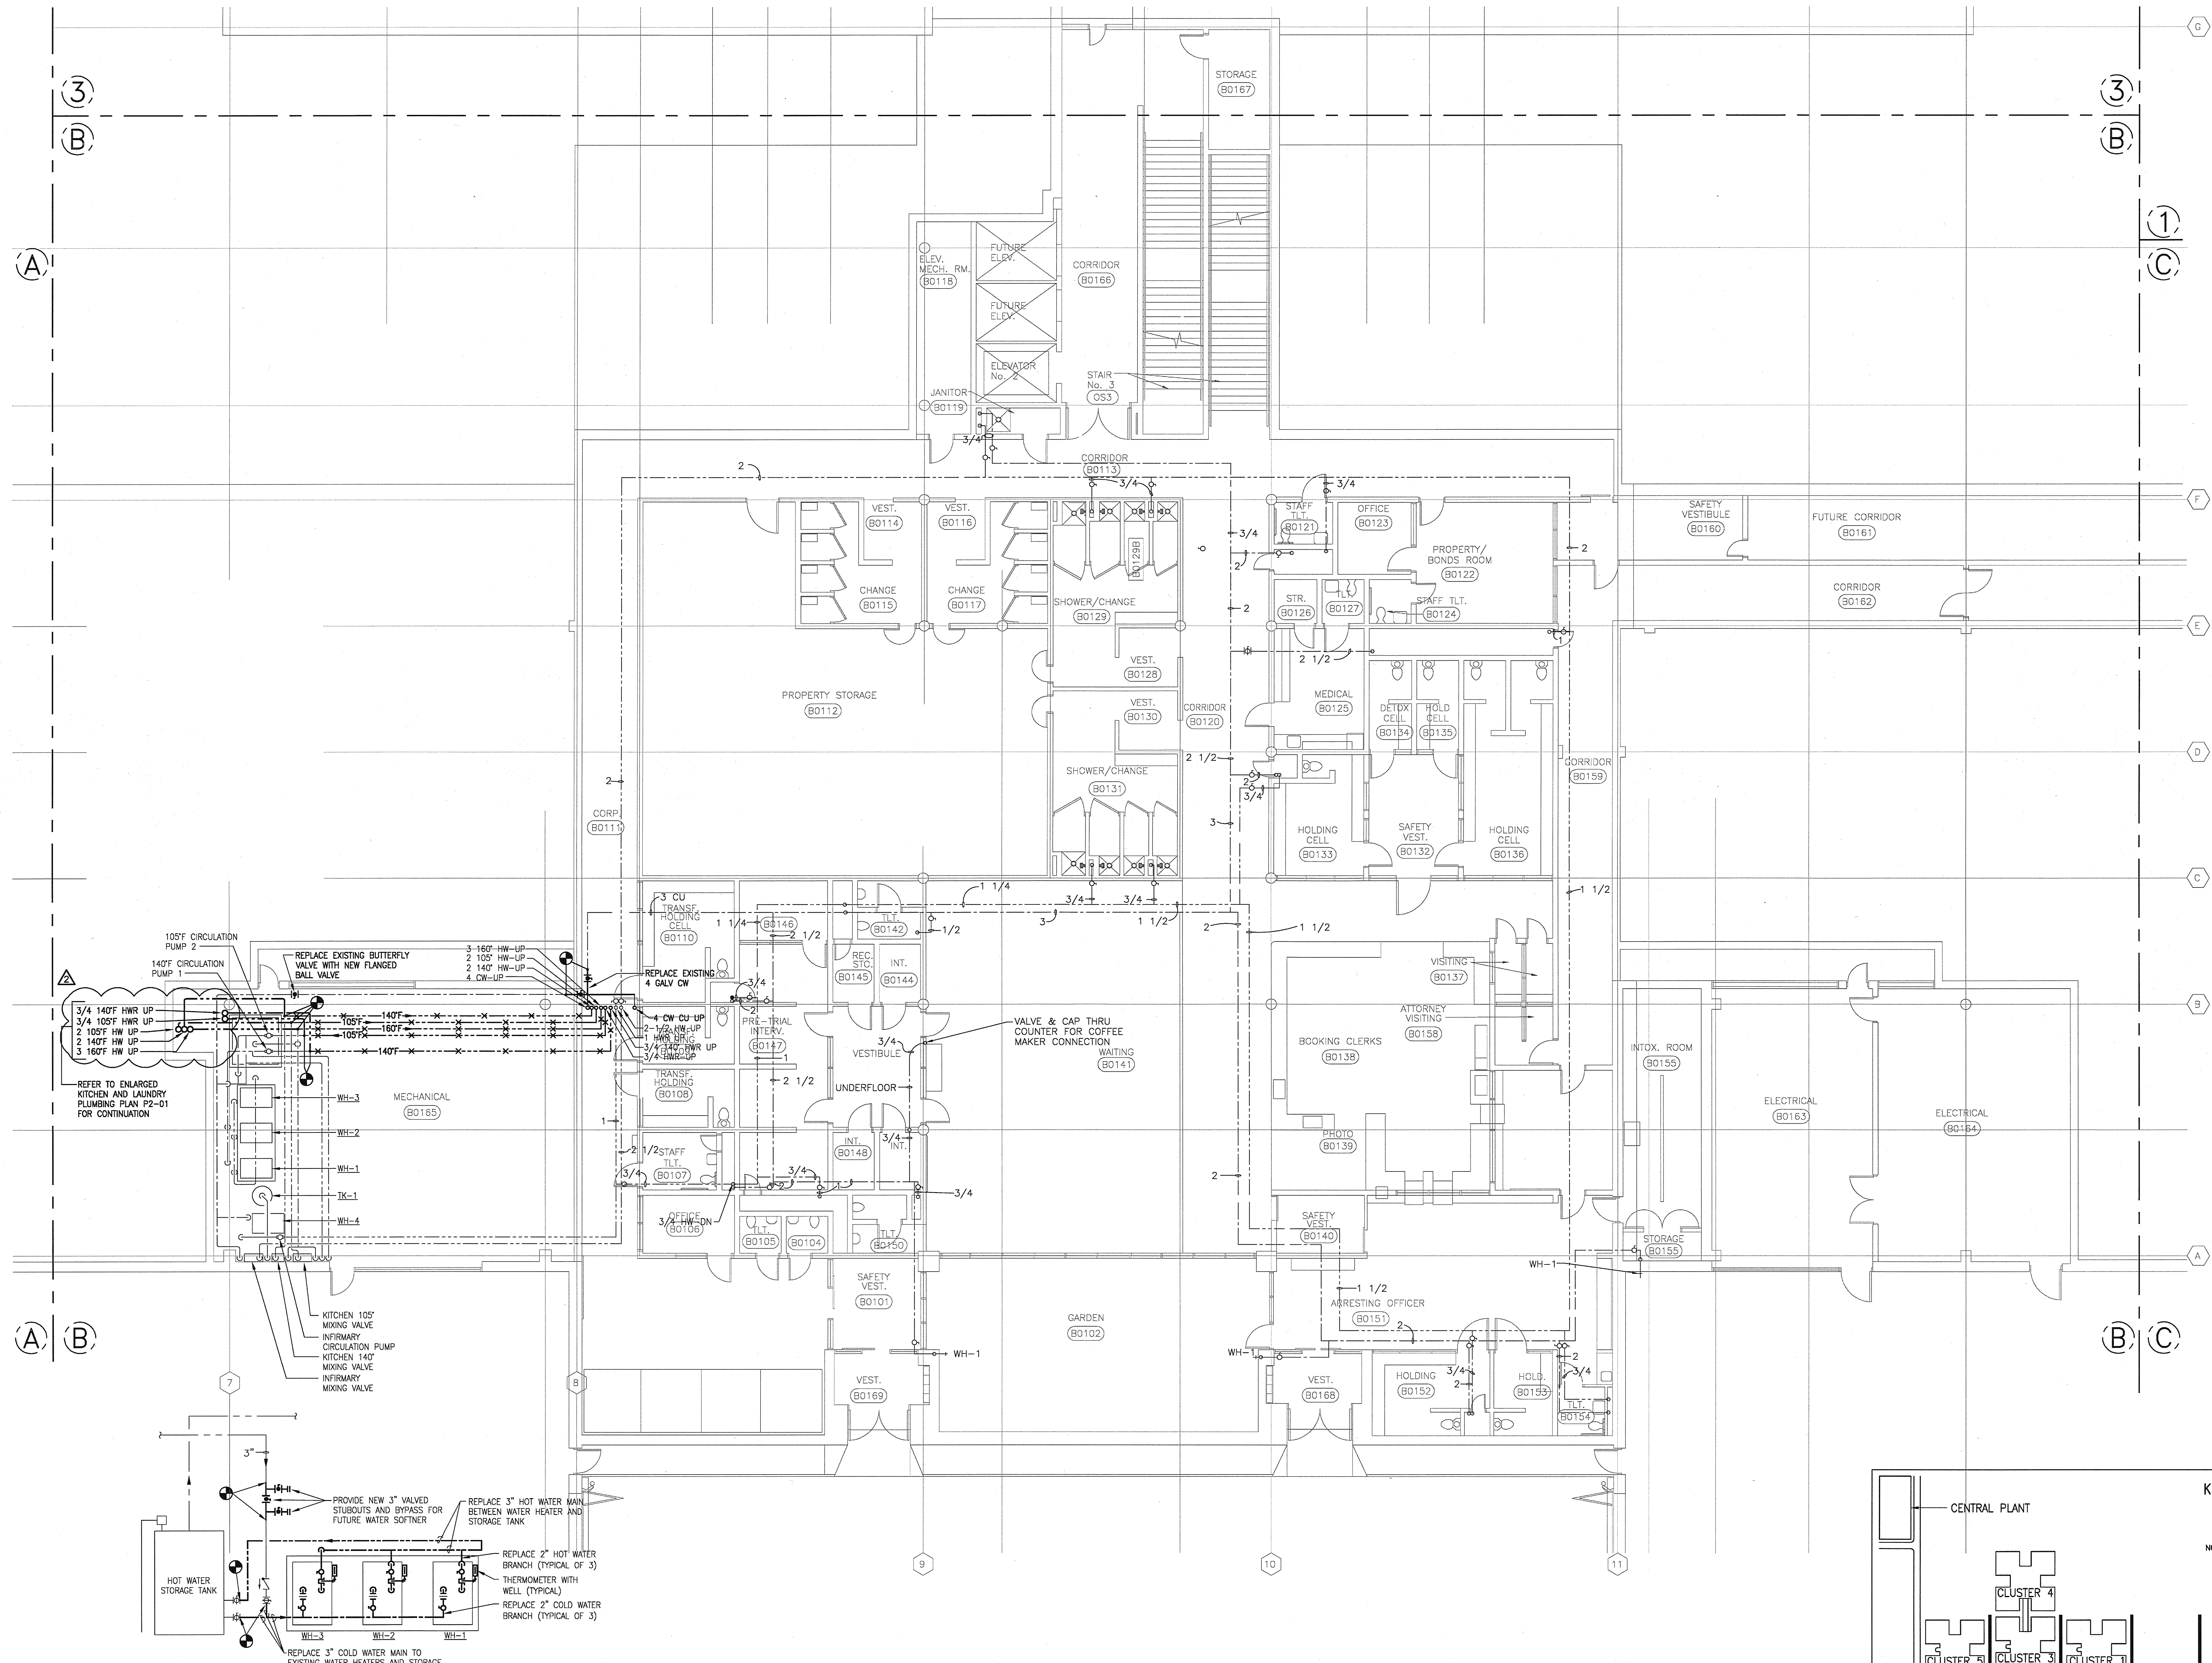


PIPING DIAGRAM FOR BOILER ROOM B0165 NEW STUBOUTS
AND BYPASS FOR FUTURE WATER SOFTNER AND NEW
MANIFOLDS AND BRANCHES TO EXISTING BOILERS
SCALE: N.T.S.

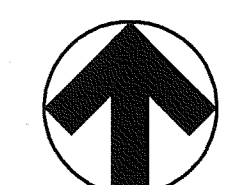

01 AREA B LOWER LEVEL PLUMBING PLAN
SCALE: 1/8" = 1'-0"

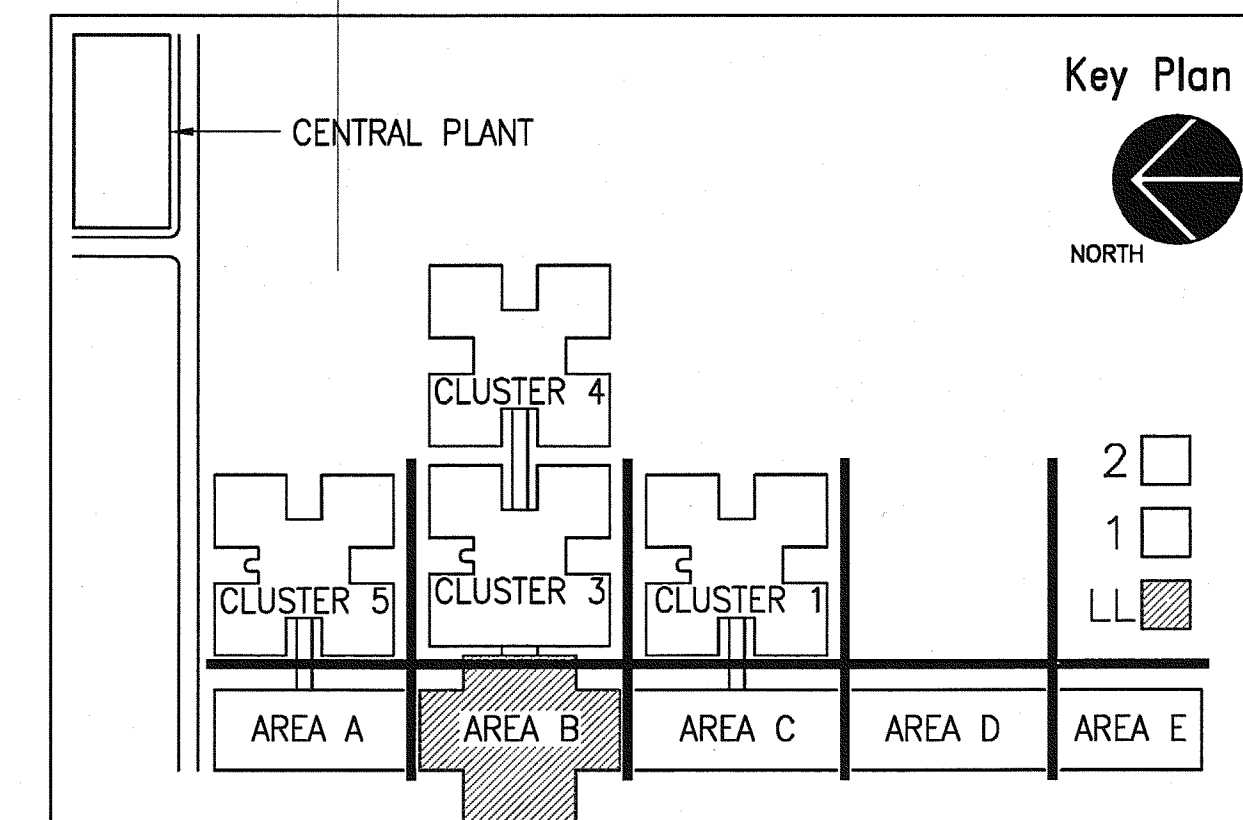


JUSTICE CENTER DOMESTIC WATER LINE REPLACEMENT
McKinney, Texas

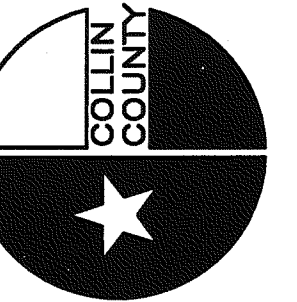


HALFF
1201 N. BOWSER ROAD
RICHARDSON, TEXAS 75081
TEL: (972) 348-2000
FAX: (972) 348-2001
WWW.HALFF.COM

Revision	Date	Description
1	7/27/2011	REVISION 2

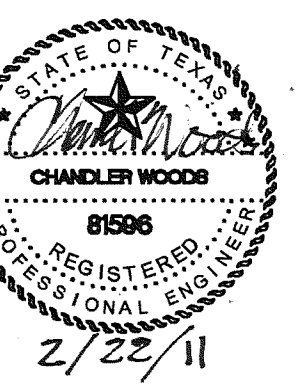


THE SEAL APPEARING ON THIS DOCUMENT WAS AUTHORIZED BY CHANDLER WOODS, P.E. 81596 ON 07/21/10. ALTERATION OF A SEALED DOCUMENT WITHOUT PROPER NOTIFICATION TO THE RESPONSIBLE ENGINEER IS AN OFFENSE UNDER THE TEXAS ENGINEERING PRACTICE ACT. THE RECORD COPY OF THIS DRAWING IS ON FILE AT THE OFFICES OF HALFF, 1201 N. BOWSER ROAD, RICHARDSON, TEXAS 75081

Project No.: 27183
Issued: 07/21/2010
Drawn By: BO
Checked By: CW
Scale: AS NOTED
Sheet Title: AREA B LOWER LEVEL PLUMBING PLAN
P1-02
Sheet Number

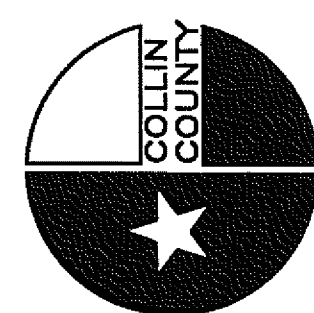

201 N. BOWSER ROAD
RICHARDSON, TEXAS 75081-2275
TEL (214) 346-6200
FAX (214) 739-0095
TBBPE FIRM NO. 312
MVO 27182

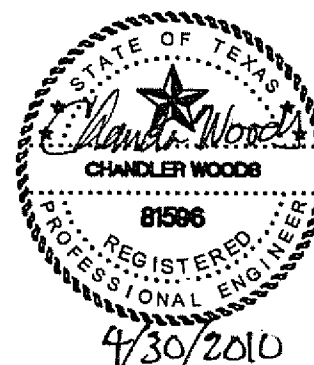[illegible]



THE SEAL APPEARING ON THIS DOCUMENT WAS AUTHORIZED BY CHANDLER WOODS, P.E. 81596 ON 04/30/10. ALTERATION OF A SEALED DOCUMENT WITHOUT PROPER NOTIFICATION TO THE RESPONSIBLE ENGINEER IS AN OFFENSE UNDER THE TEXAS ENGINEERING PRACTICE ACT. THE RECORD COPY OF THIS DRAWING IS ON FILE AT THE OFFICES OF HALFF, 1201 N. BOWSER ROAD, RICHARDSON, TEXAS 75081

Project No.:	27183
Issued:	04/30/2010
Drawn By:	BO
Checked By:	CW
Scale:	AS NOTED

Sheet Title

AREA B
LOWER LEVEL
PLUMBING PLAN

P1-02

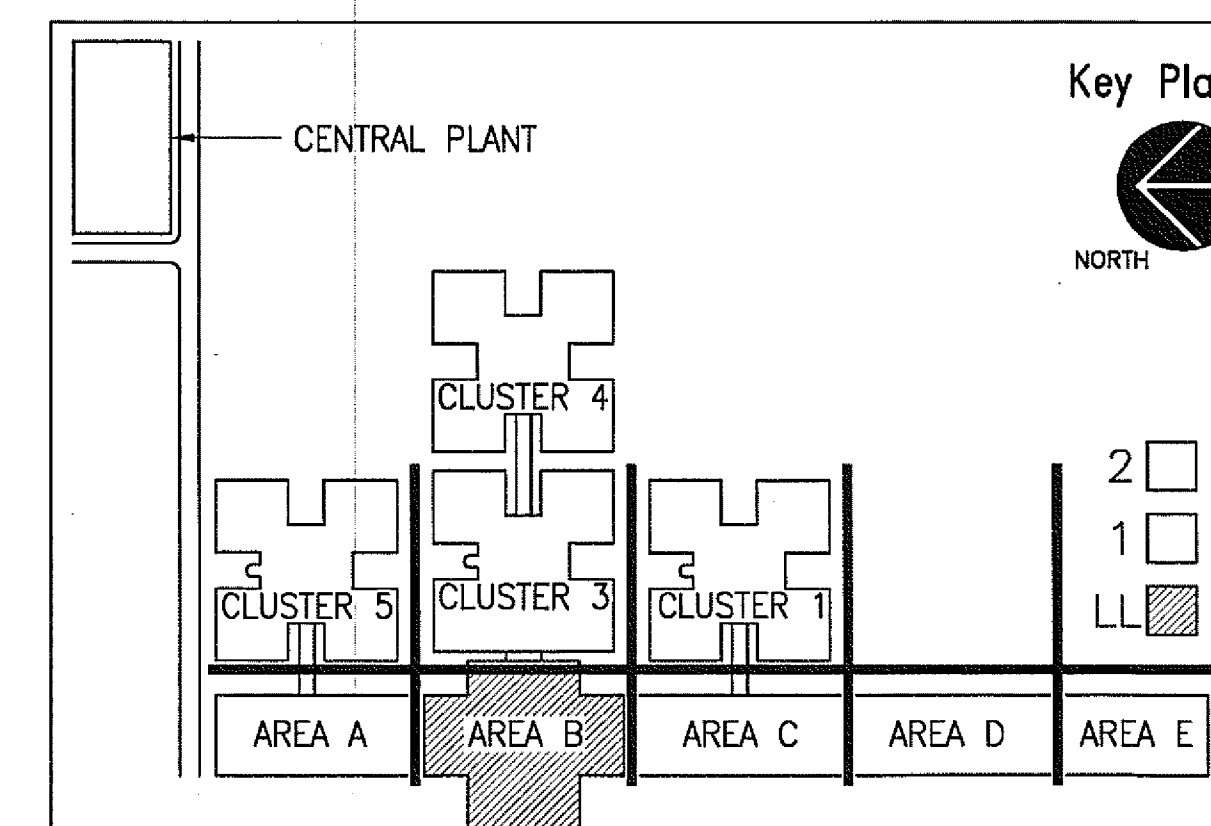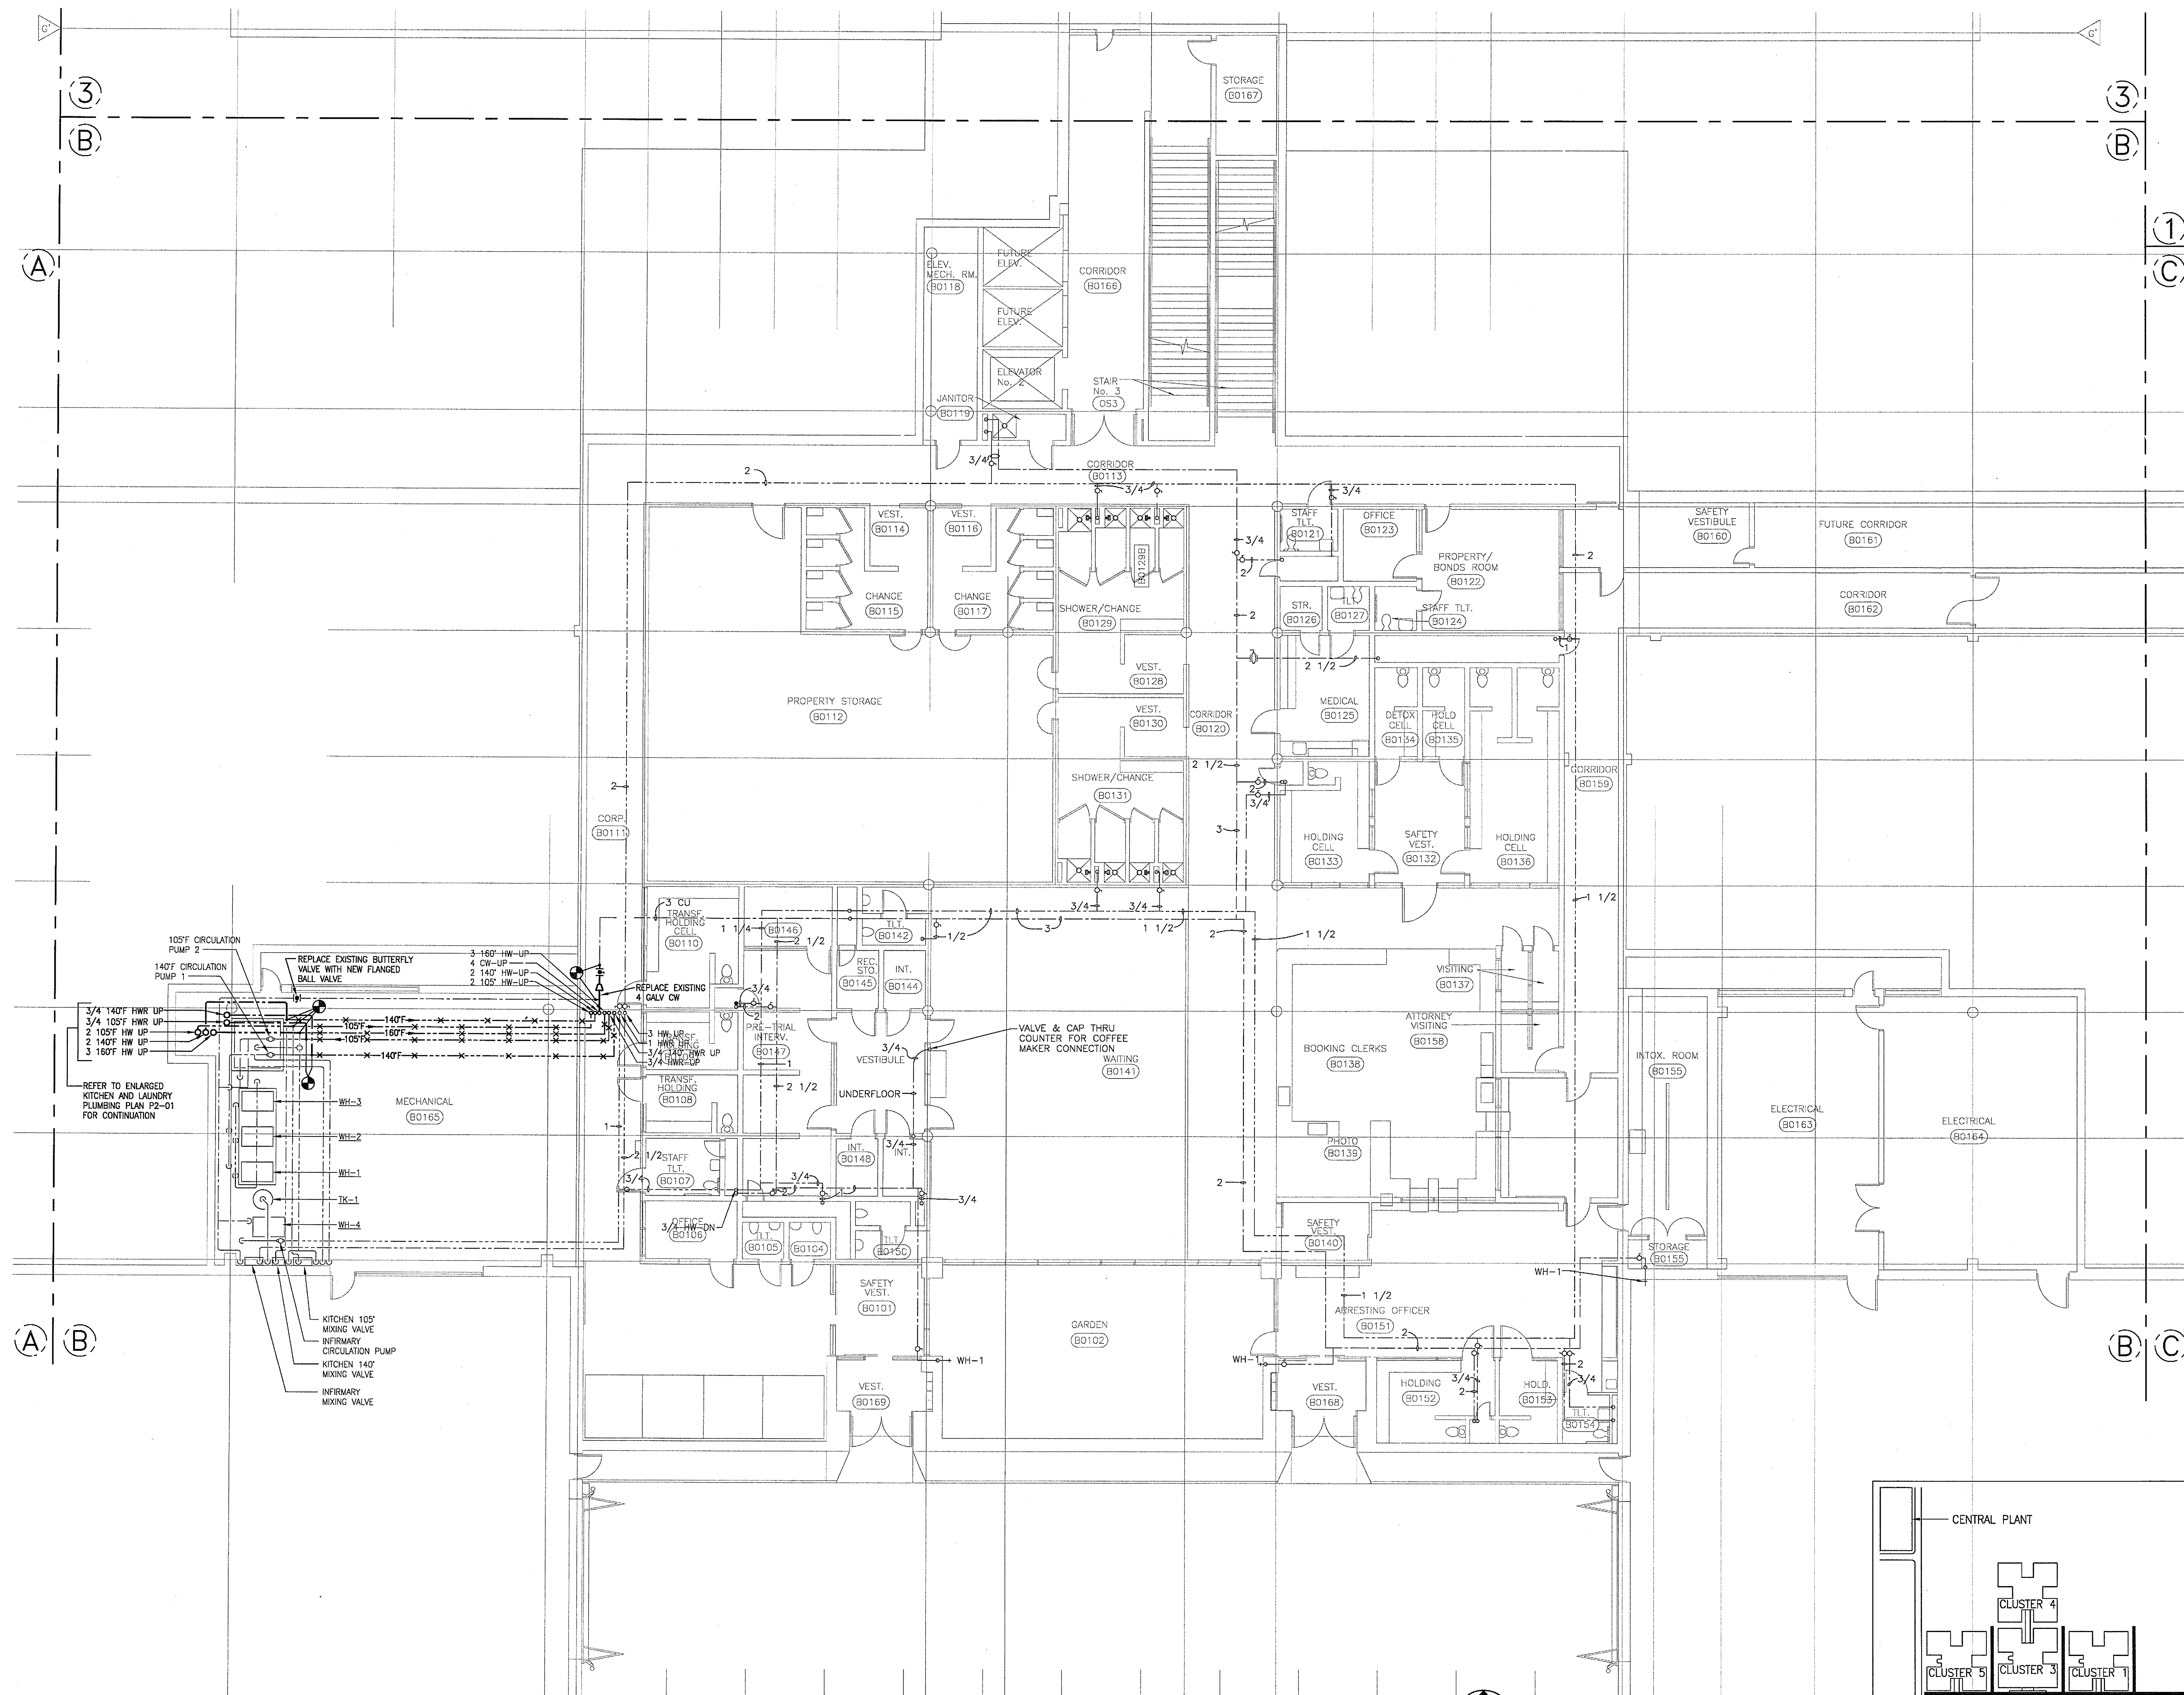


 **01** AREA B LOWER LEVEL PLUMBING PLAN
SCALE: 1/8" = 1'-0"


[illegible]

THE SEAL APPEARING ON THIS DOCUMENT WAS AUTHORIZED BY CHANDLER WOODS, P.E. #18596 ON 07/21/10. ALTERATION OF A SEALED DOCUMENT WITHOUT PROPER NOTIFICATION TO THE RESPONSIBLE ENGINEER IS AN OFFENSE UNDER THE TEXAS ENGINEERING PRACTICE ACT. THE RECORD COPY OF THIS DRAWING IS ON FILE AT THE OFFICES OF HALFF, 1201 N. BOWSER ROAD, RICHARDSON, TEXAS 75081

Project No.:	27183
Issued:	07/21/2010
Drawn By:	BO
Checked By:	CW
Scale:	AS NOTED
Sheet Title	
AREA B FIRST FLOOR PLUMBING PLAN	
P1-04	
Sheet Number	

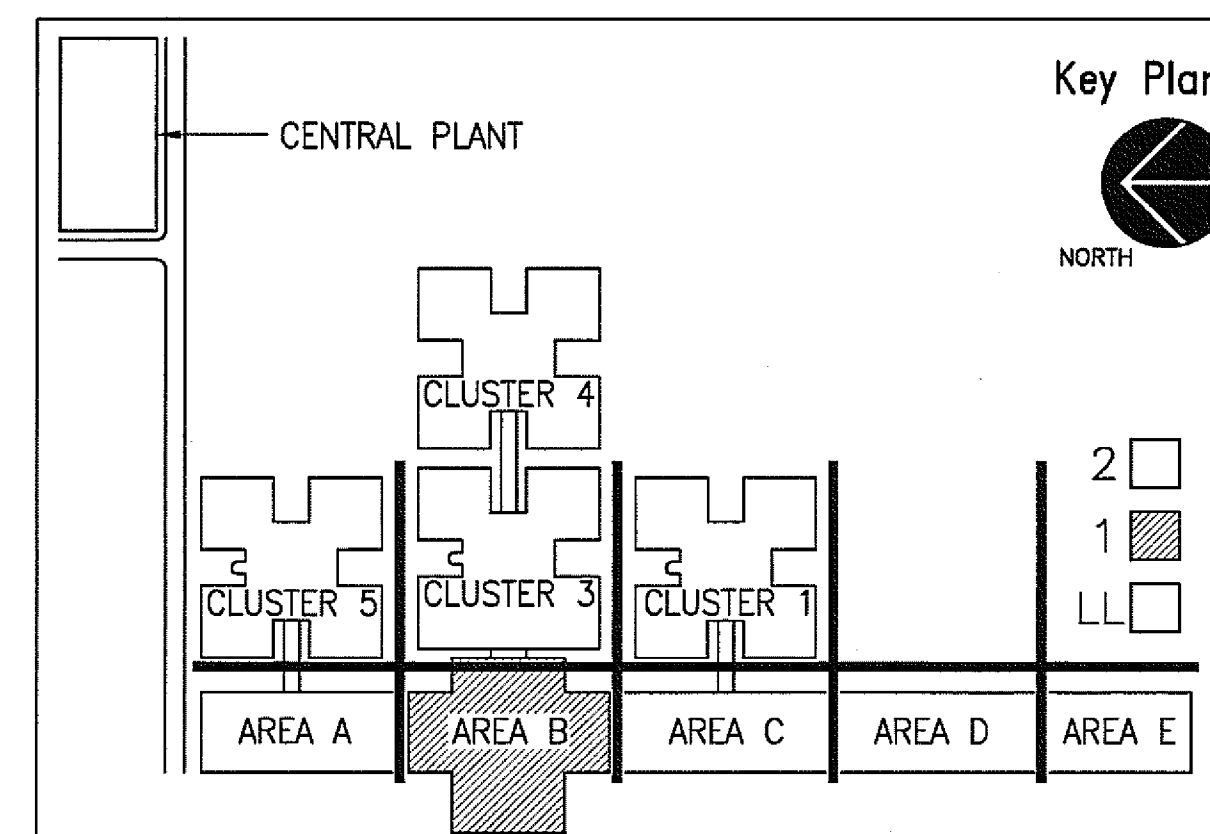


 01 AREA B FIRST FLOOR PLUMBING PLAN
SCALE: 1/8" = 1'-0"

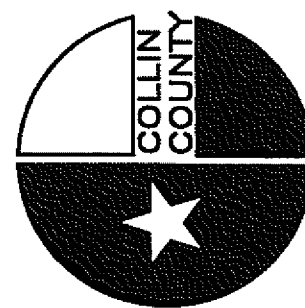

HALFF
CITY OF DALLAS
1201 N. BOWSER ROAD
RICHARDSON, TEXAS 75081
TEL: 972.781.1275
FAX: 972.781.1276
AUG 27, 1983



Revision	No.	Date	Description

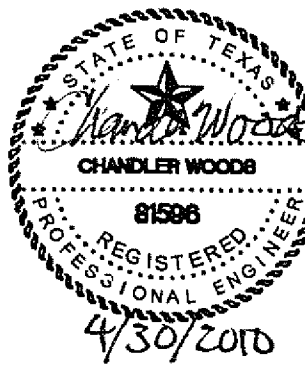

THE SEAL APPEARING ON THIS DOCUMENT WAS AUTHORIZED BY CHANDLER WOODS, P.E. 81596 ON 04/30/10 ALTERATION OF A SEALED DOCUMENT WITHOUT PROPER NOTIFICATION TO THE RESPONSIBLE ENGINEER IS AN OFFENSE UNDER THE TEXAS ENGINEERING PRACTICE ACT. THE RECORD COPY OF THIS DRAWING IS ON FILE AT THE OFFICES OF HALFF, 1201 N. BOWSER ROAD, RICHARDSON, TEXAS 75081



Project No.: 27183
Issued: 04/30/2010
Drawn By: BO
Checked By: CW
Scale: AS NOTED
Sheet Title: ENLARGED KITCHEN & LAUNDRY PLUMBING PLAN

P2-01
Sheet Number

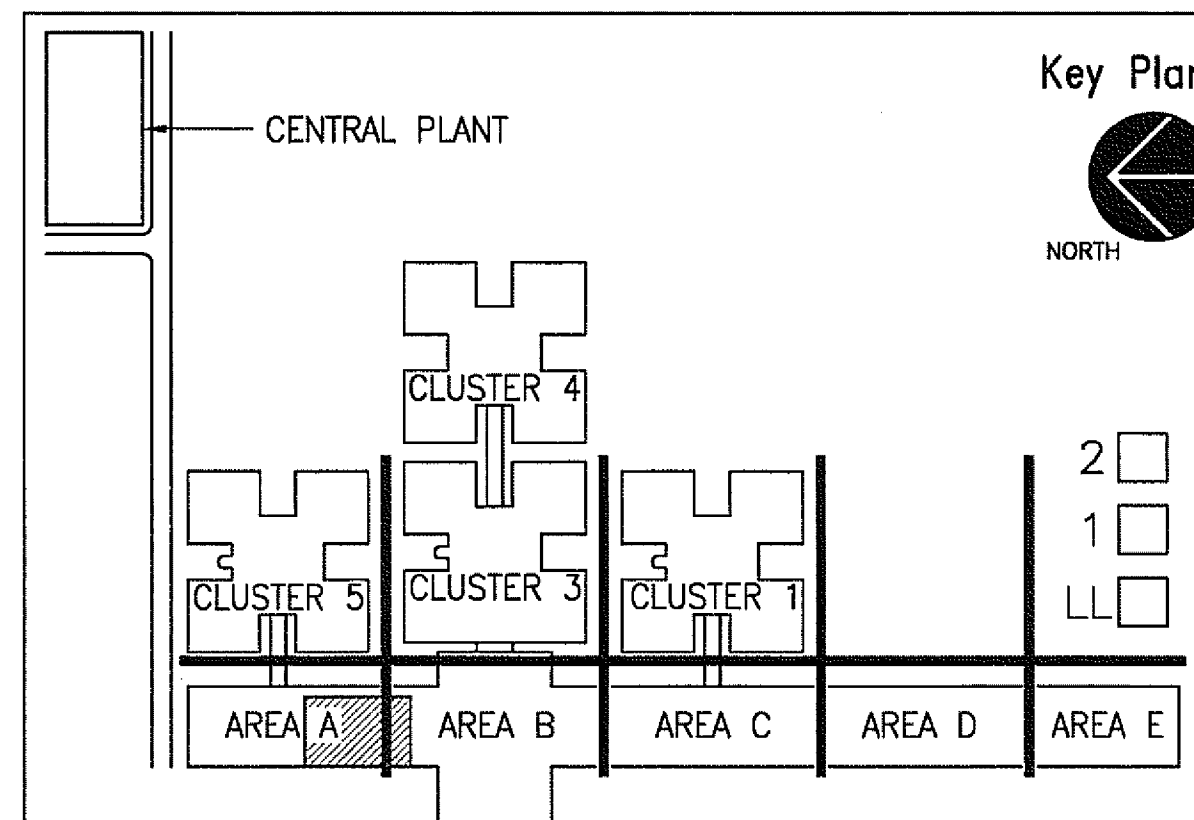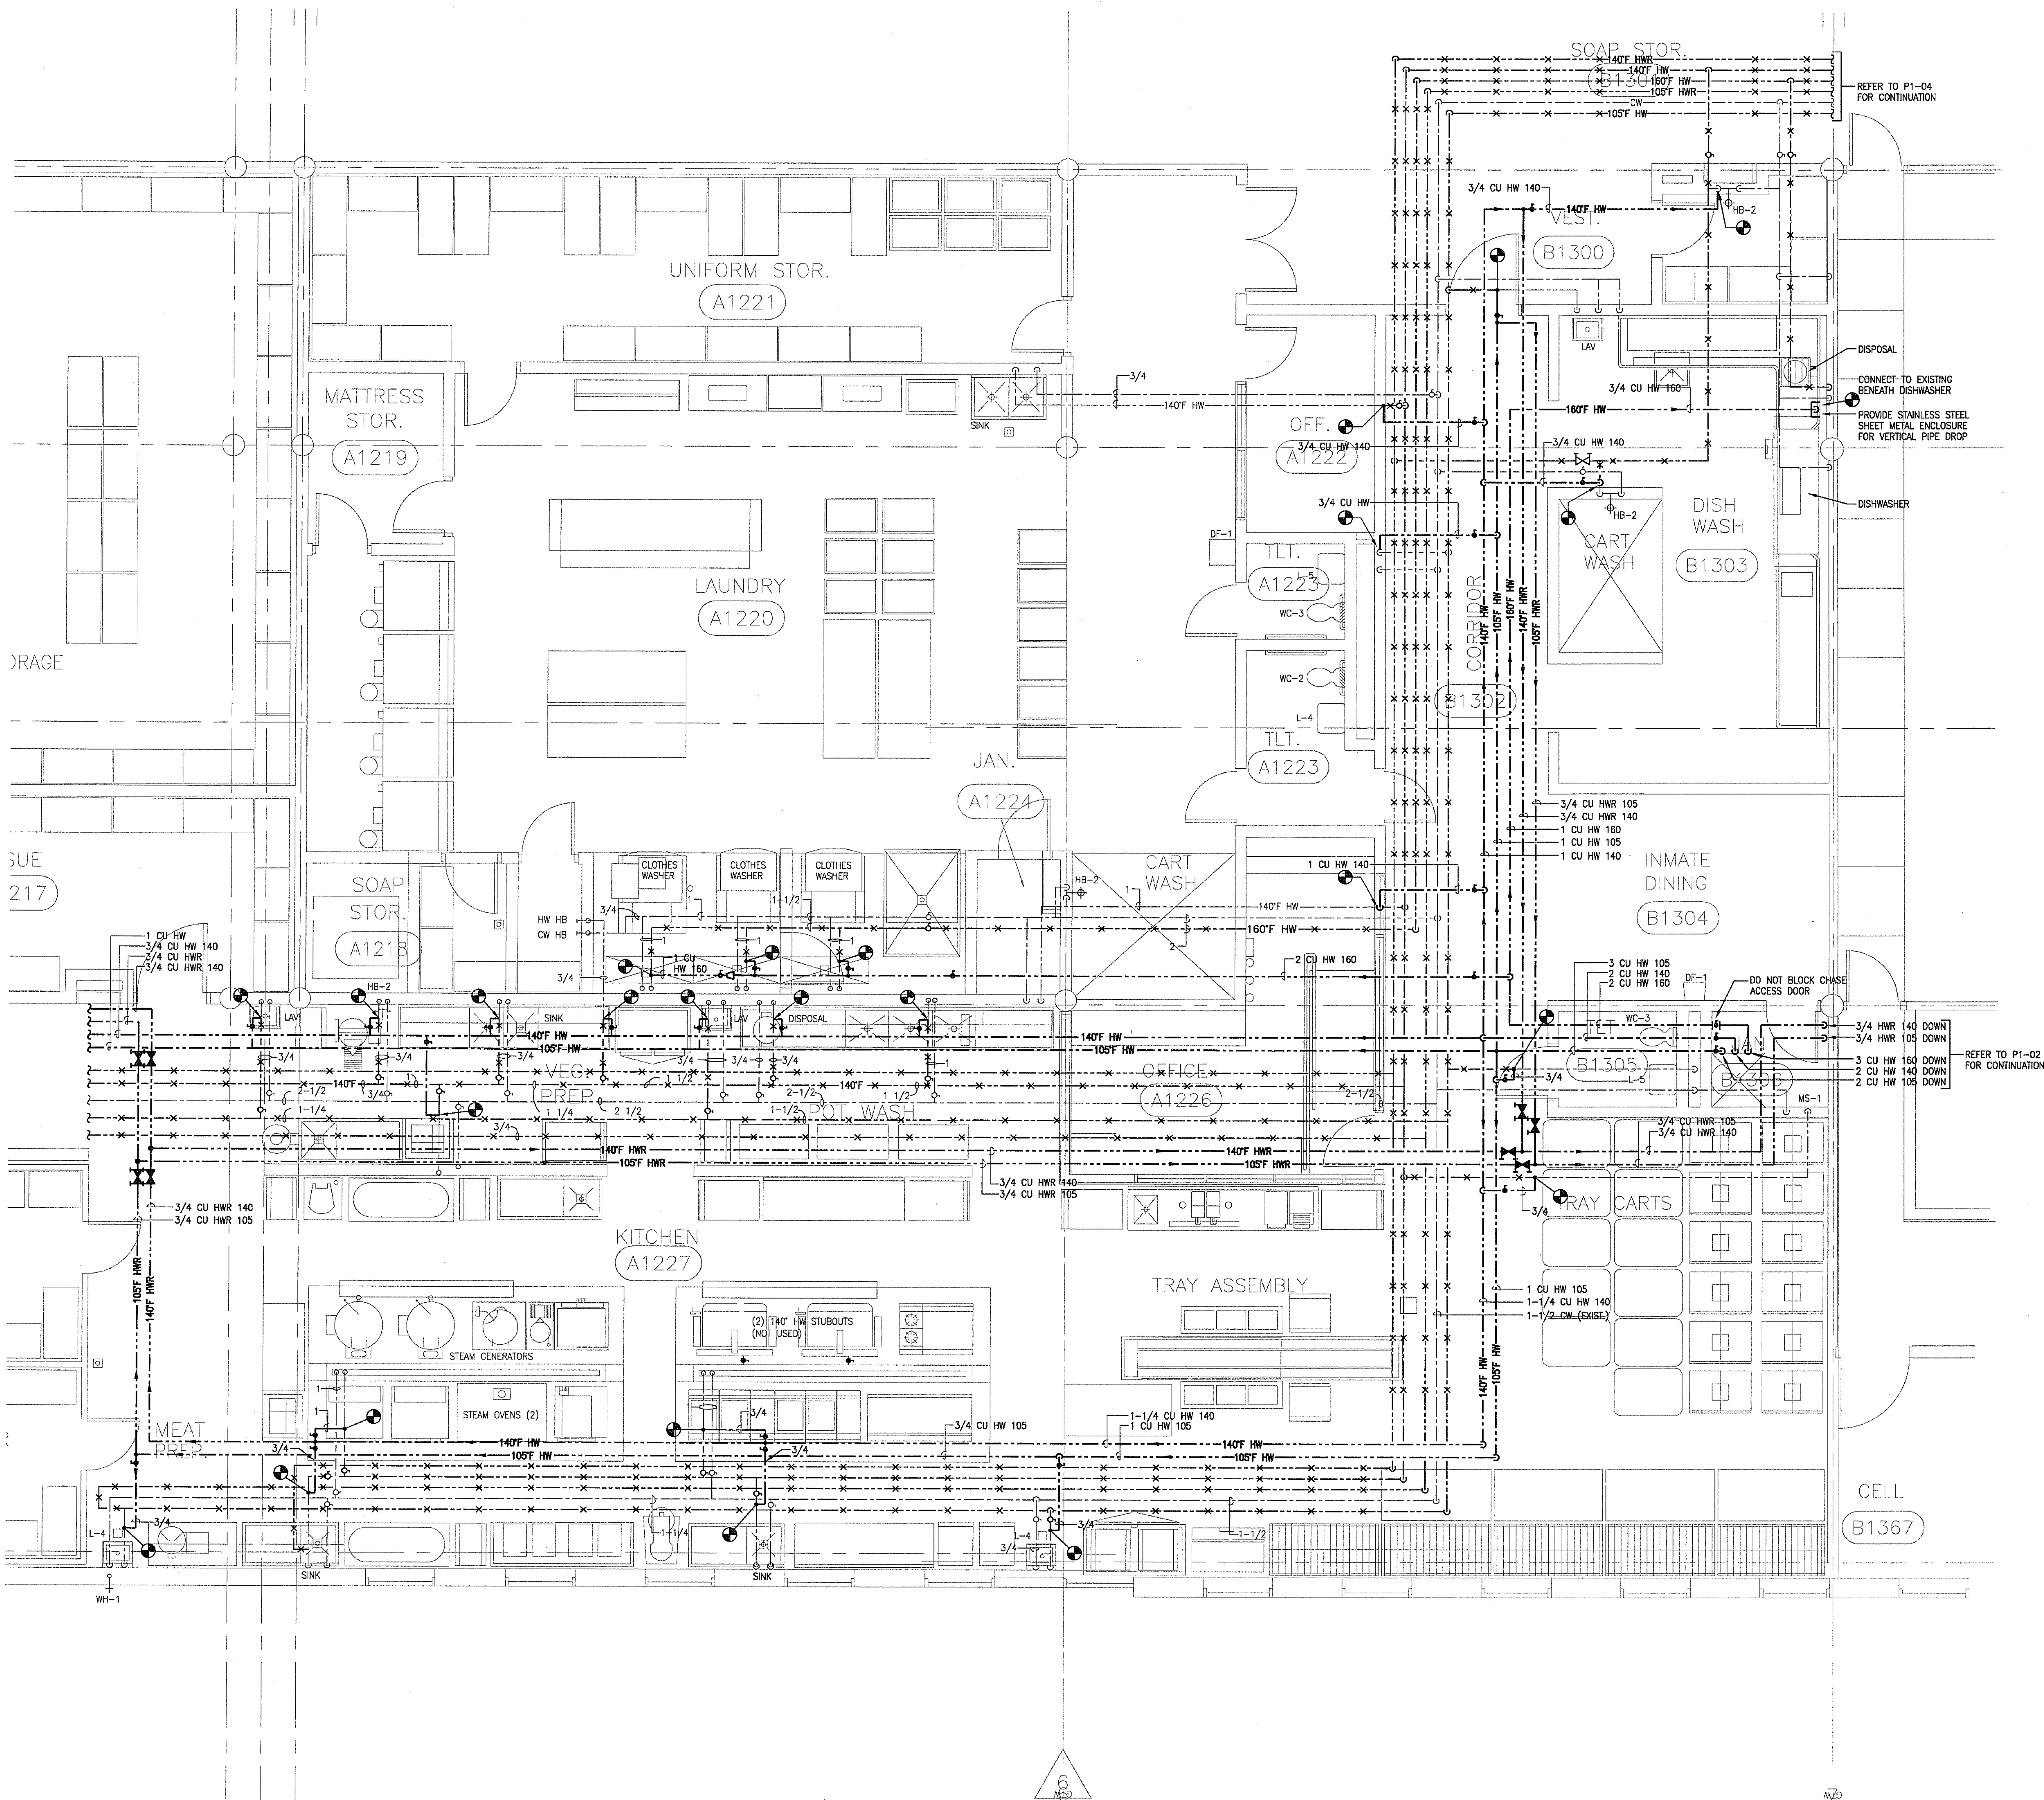


01 ENLARGED KITCHEN & LAUNDRY PLUMBING PLAN
SCALE: 1/4" = 1'-0"

File Name: I:\27000s\27183\CADD\201-EP-27183.dwg
Current Tab (Layout): LAYOUT1 User: AH2519
Printed Date: 1/22/2010 2:56:08 PM

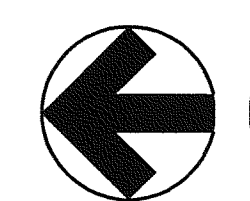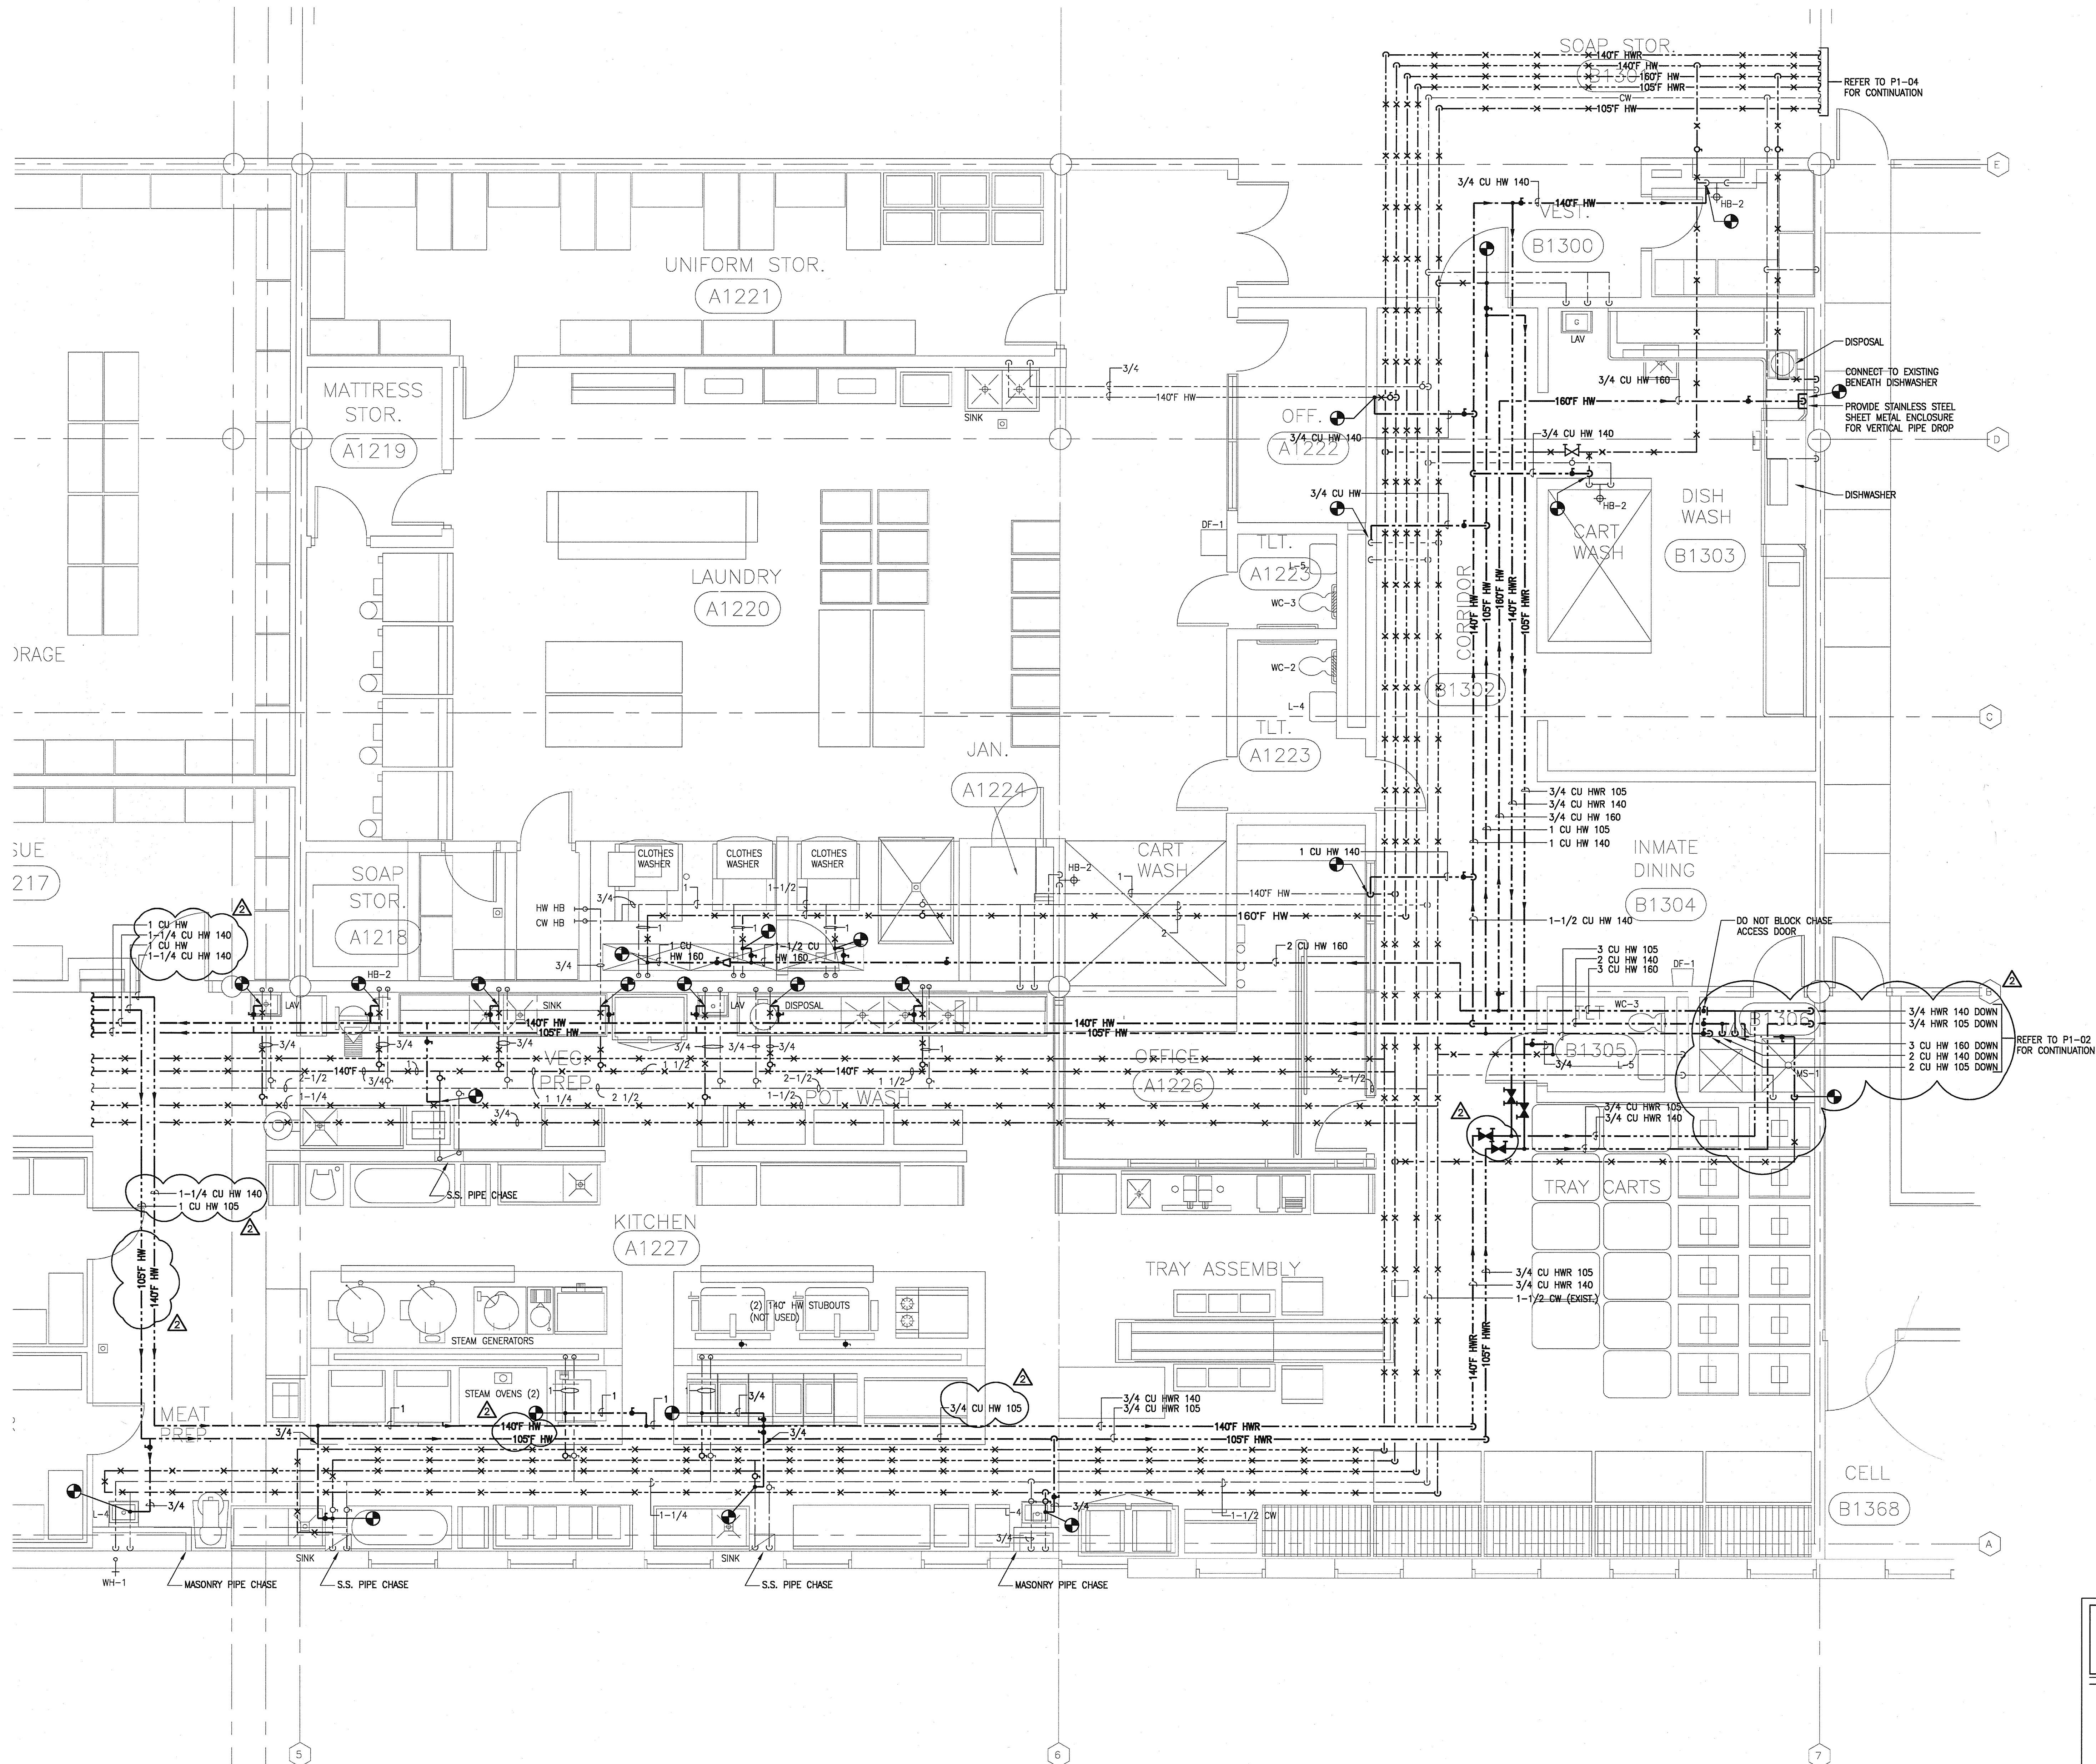


01 ENLARGED KITCHEN & LAUNDRY PLUMBING PLAN
SCALE: 1/4" = 1'-0"

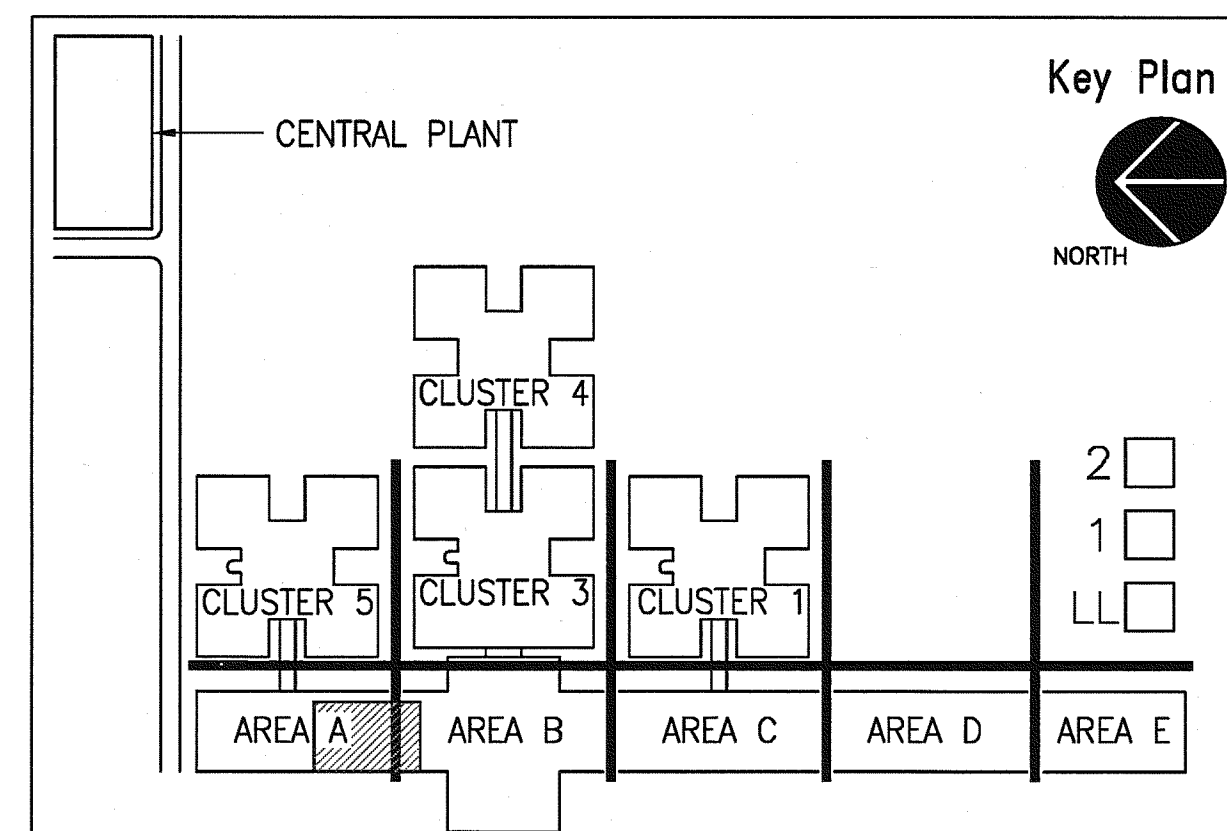

JUSTICE CENTER DOMESTIC WATER LINE REPLACEMENT

McKinney, Texas

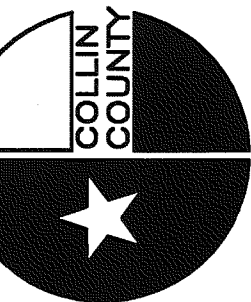

HALFF


1201 N. BOWSER ROAD
DALLAS, TEXAS 75208-2275
TEL: (214) 341-3400
FAX: (214) 341-3401
WWW.HALFF.COM

Revision	Date	Description
1	7/22/2011	REVISION 2



THE SEAL APPEARING ON THIS DOCUMENT WAS AUTHORIZED BY CHANDLER WOODS, P.E. 81696 ON 07/21/10. ALTERATION OF A SEALED DOCUMENT WITHOUT PROPER NOTIFICATION TO THE RESPONSIBLE ENGINEER IS AN OFFENSE UNDER THE TEXAS ENGINEERING PRACTICE ACT. THE RECORD COPY OF THIS DRAWING IS ON FILE AT THE OFFICES OF HALFF, 1201 N. BOWSER ROAD, RICHARDSON, TEXAS 75081

Project No.: 27183
Issued: 07/21/2010
Drawn By: BO
Checked By: CW
Scale: AS NOTED
Sheet Title: ENLARGED KITCHEN & LAUNDRY PLUMBING PLAN
P2-01
Sheet Number

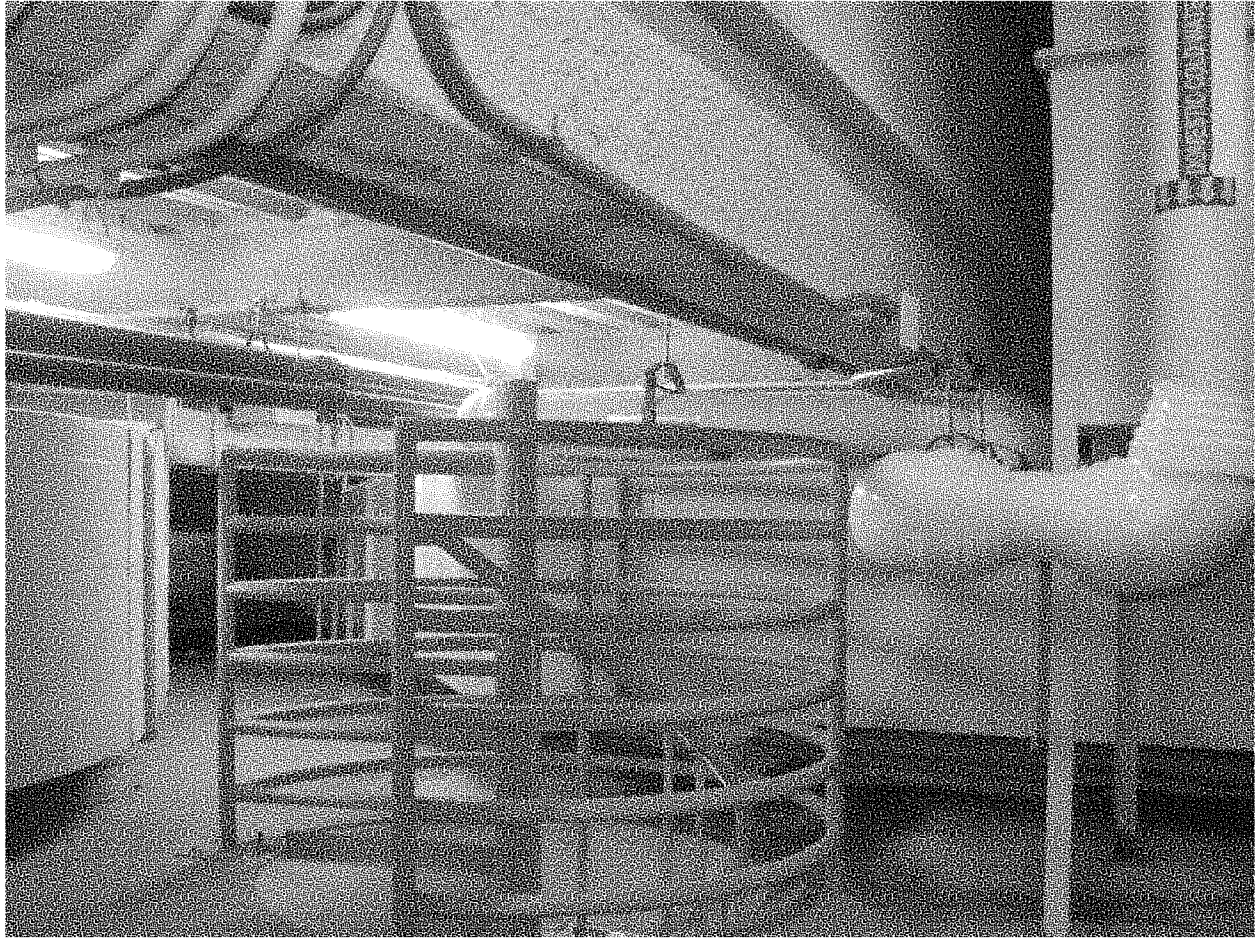


PC0 2-1 After Change Order, Example A



PC0 2-1 After Change Order, Example B



PC0 2-1 After Change Order, Example B

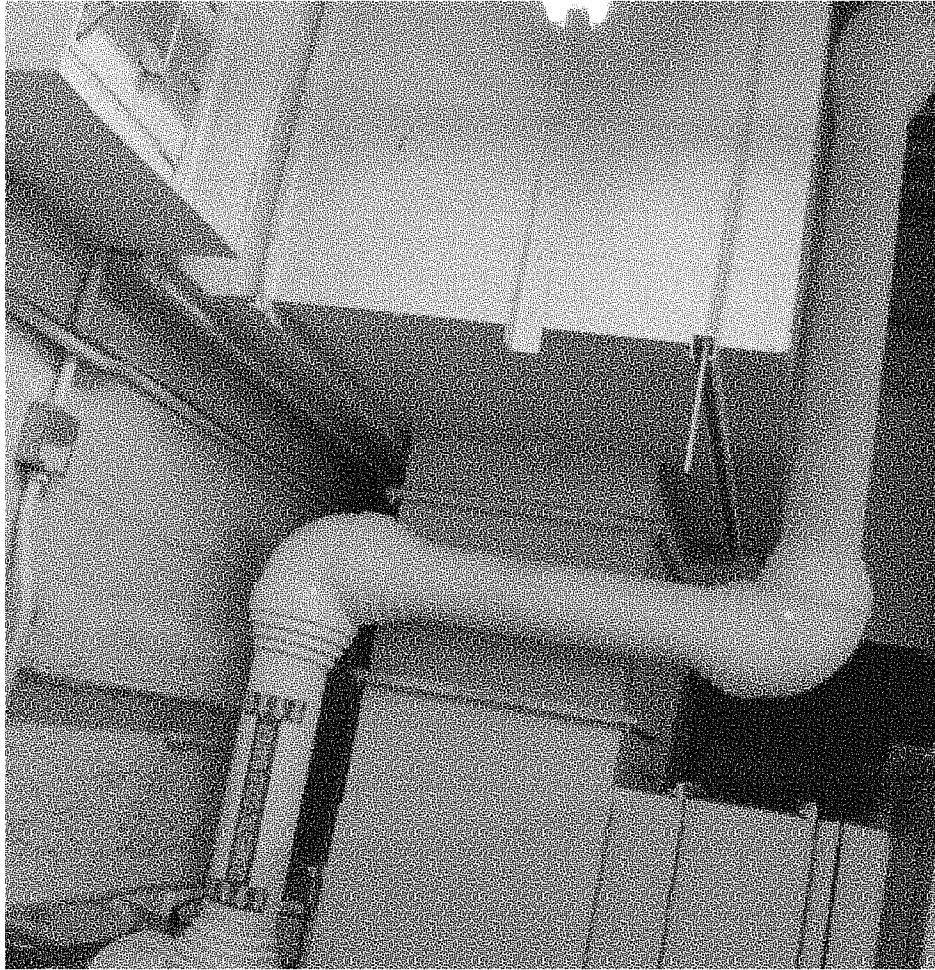


PC0 2-1 After Change Order, Example B



PC0 2-1 After Change Order, Example F




PCO 2-1 Before Change Order

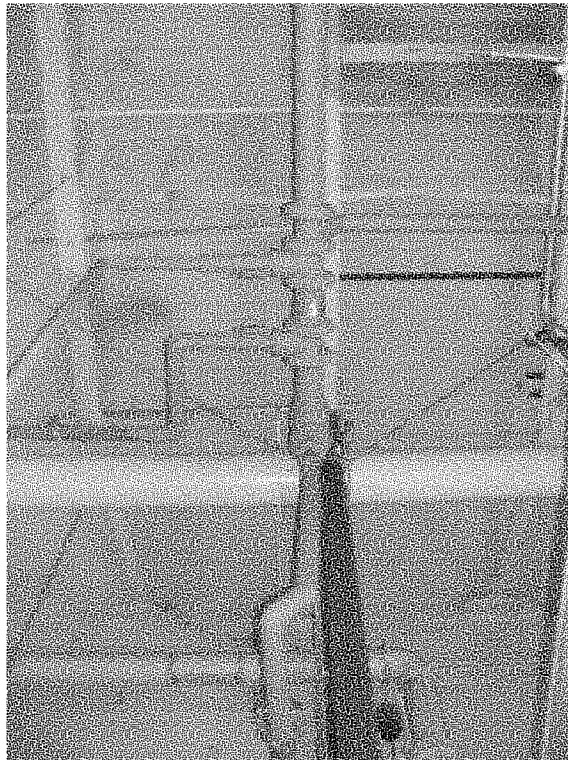

Branch Connections Included



Branch Connection Missing

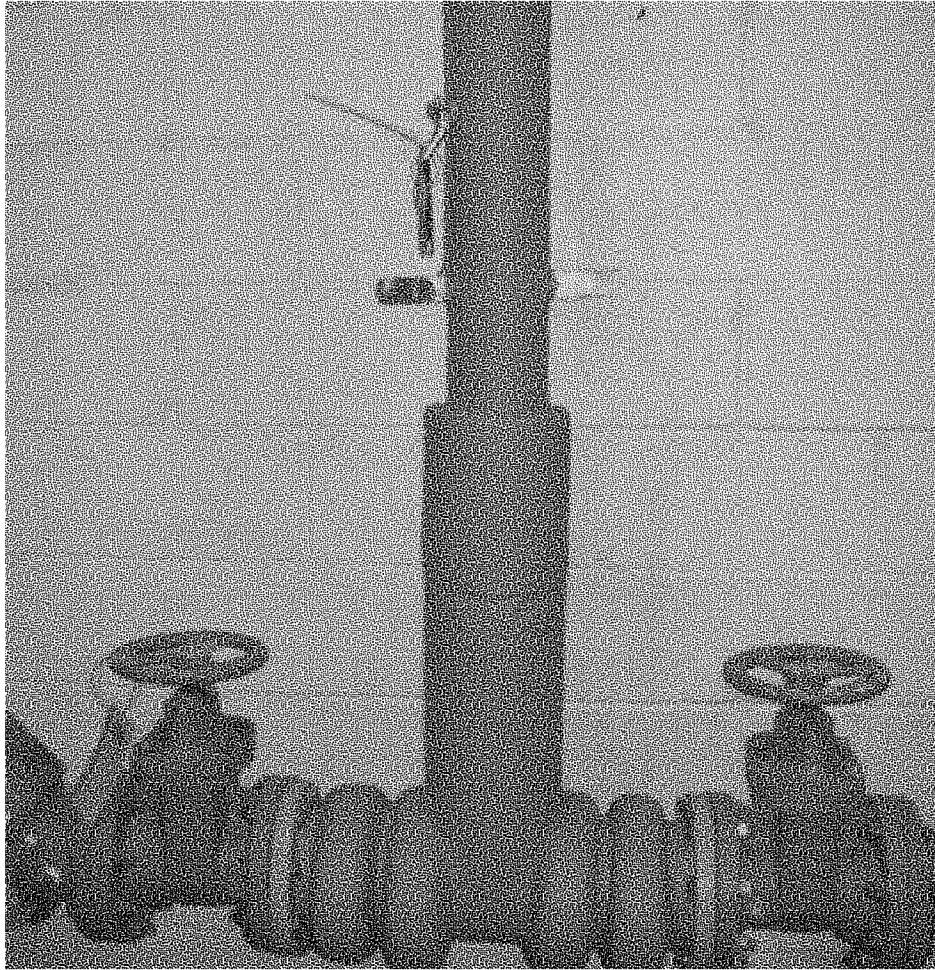

PC0 7-5 TEE Between Backflow Preventors